



SAMPLE PROJECT DOWNLOADED FROM WWW.HOT4CAD.COM

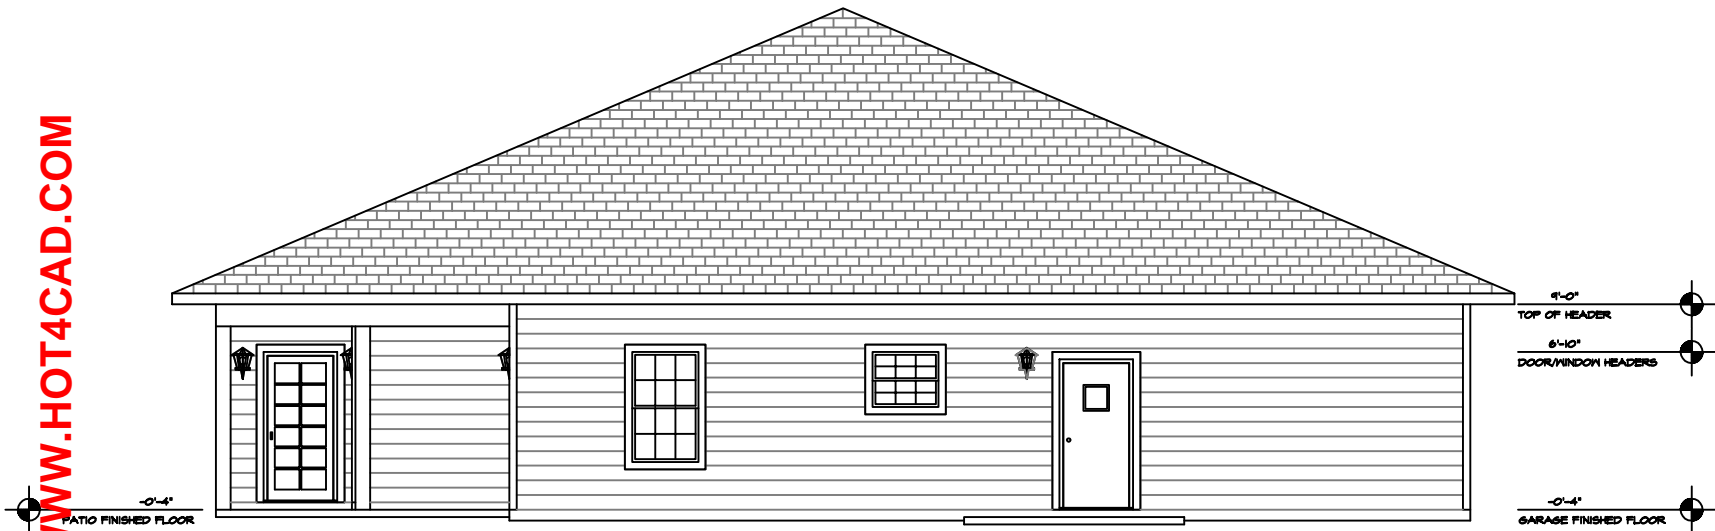

LEFT ELEVATION VIEW

SCALE


1/4" = 1'-0"

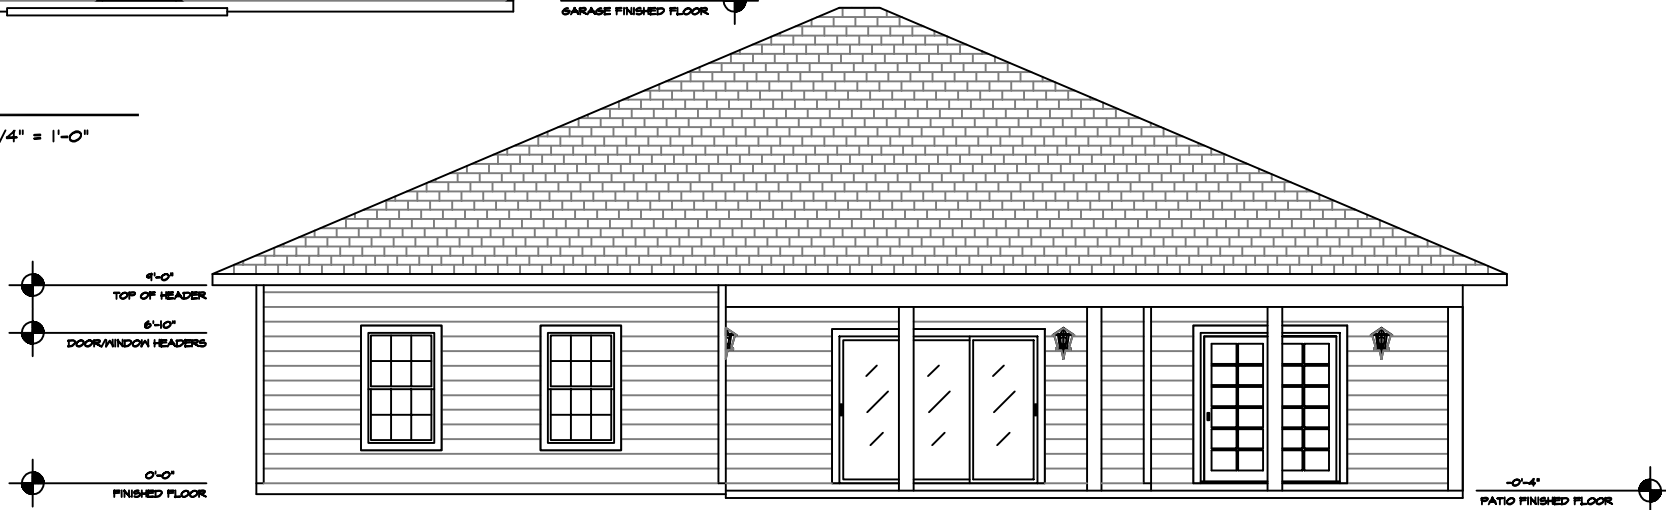

REAR ELEVATION VIEW

SCALE


1/4" = 1'-0"

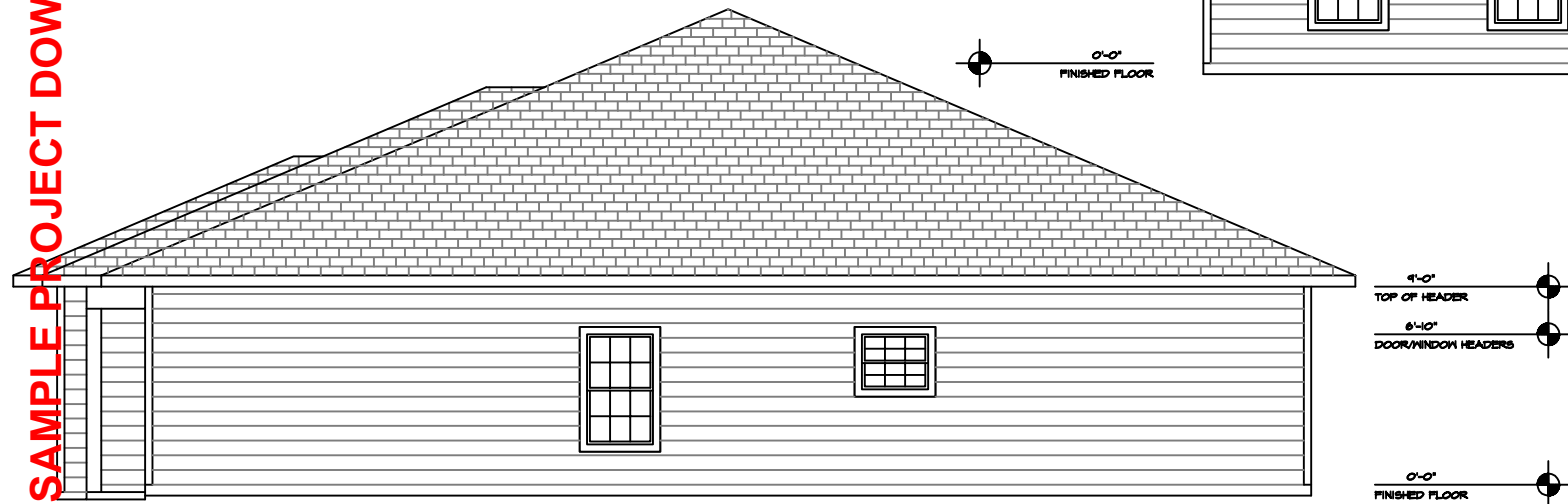

RIGHT ELEVATION VIEW

SCALE

1/4" = 1'-0"

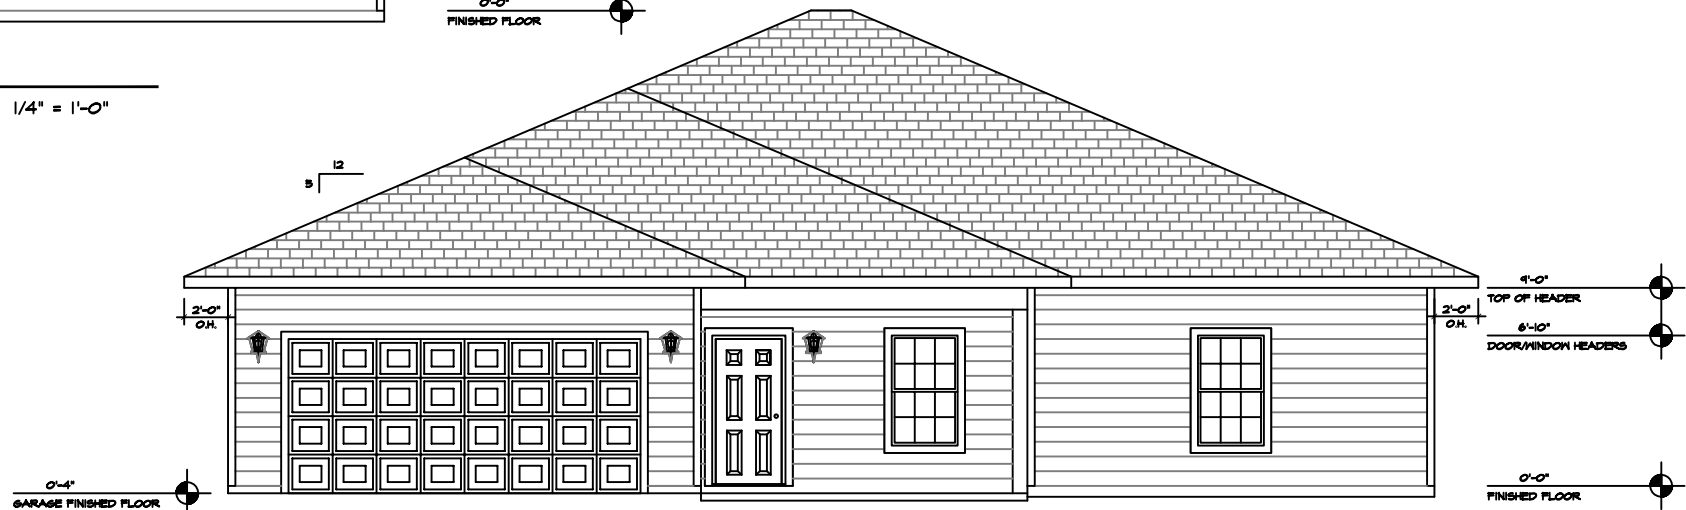

FRONT ELEVATION VIEW

SCALE

1/4" = 1'-0"


AREA CALC'S:	
LIVING	2125
GARAGE	455
LANAI	308
PORCH	143
A/C PAD	40
TOTAL	3071

A NEW RESIDENCE FOR:
MR & MRS JOHN SMITH
 123 ANYWHERE DRIVE
 CITY, STATE 0000

AUTOCAD DRAFTING PROVIDED BY:
G. L. "CHIP" HARPER
 LOCAL: (828) 388-1547 TOLL FREE: 1-866-411-1547
 FAX: (828) 388-6372 EMAIL: CHIP@HOT4CAD.COM
 WEB: WWW.HOT4CAD.COM
PRICE TO FURNISH AND FOR CONSTRUCTION NOT SHOWN. ALL WORK SHALL BE DONE IN ACCORDANCE WITH ALL APPLICABLE LOCAL, STATE AND FEDERAL REQUIREMENTS, CODES AND ZONING COMPLIANCE.

DATE:
08-23-2007

SHEET:
A1

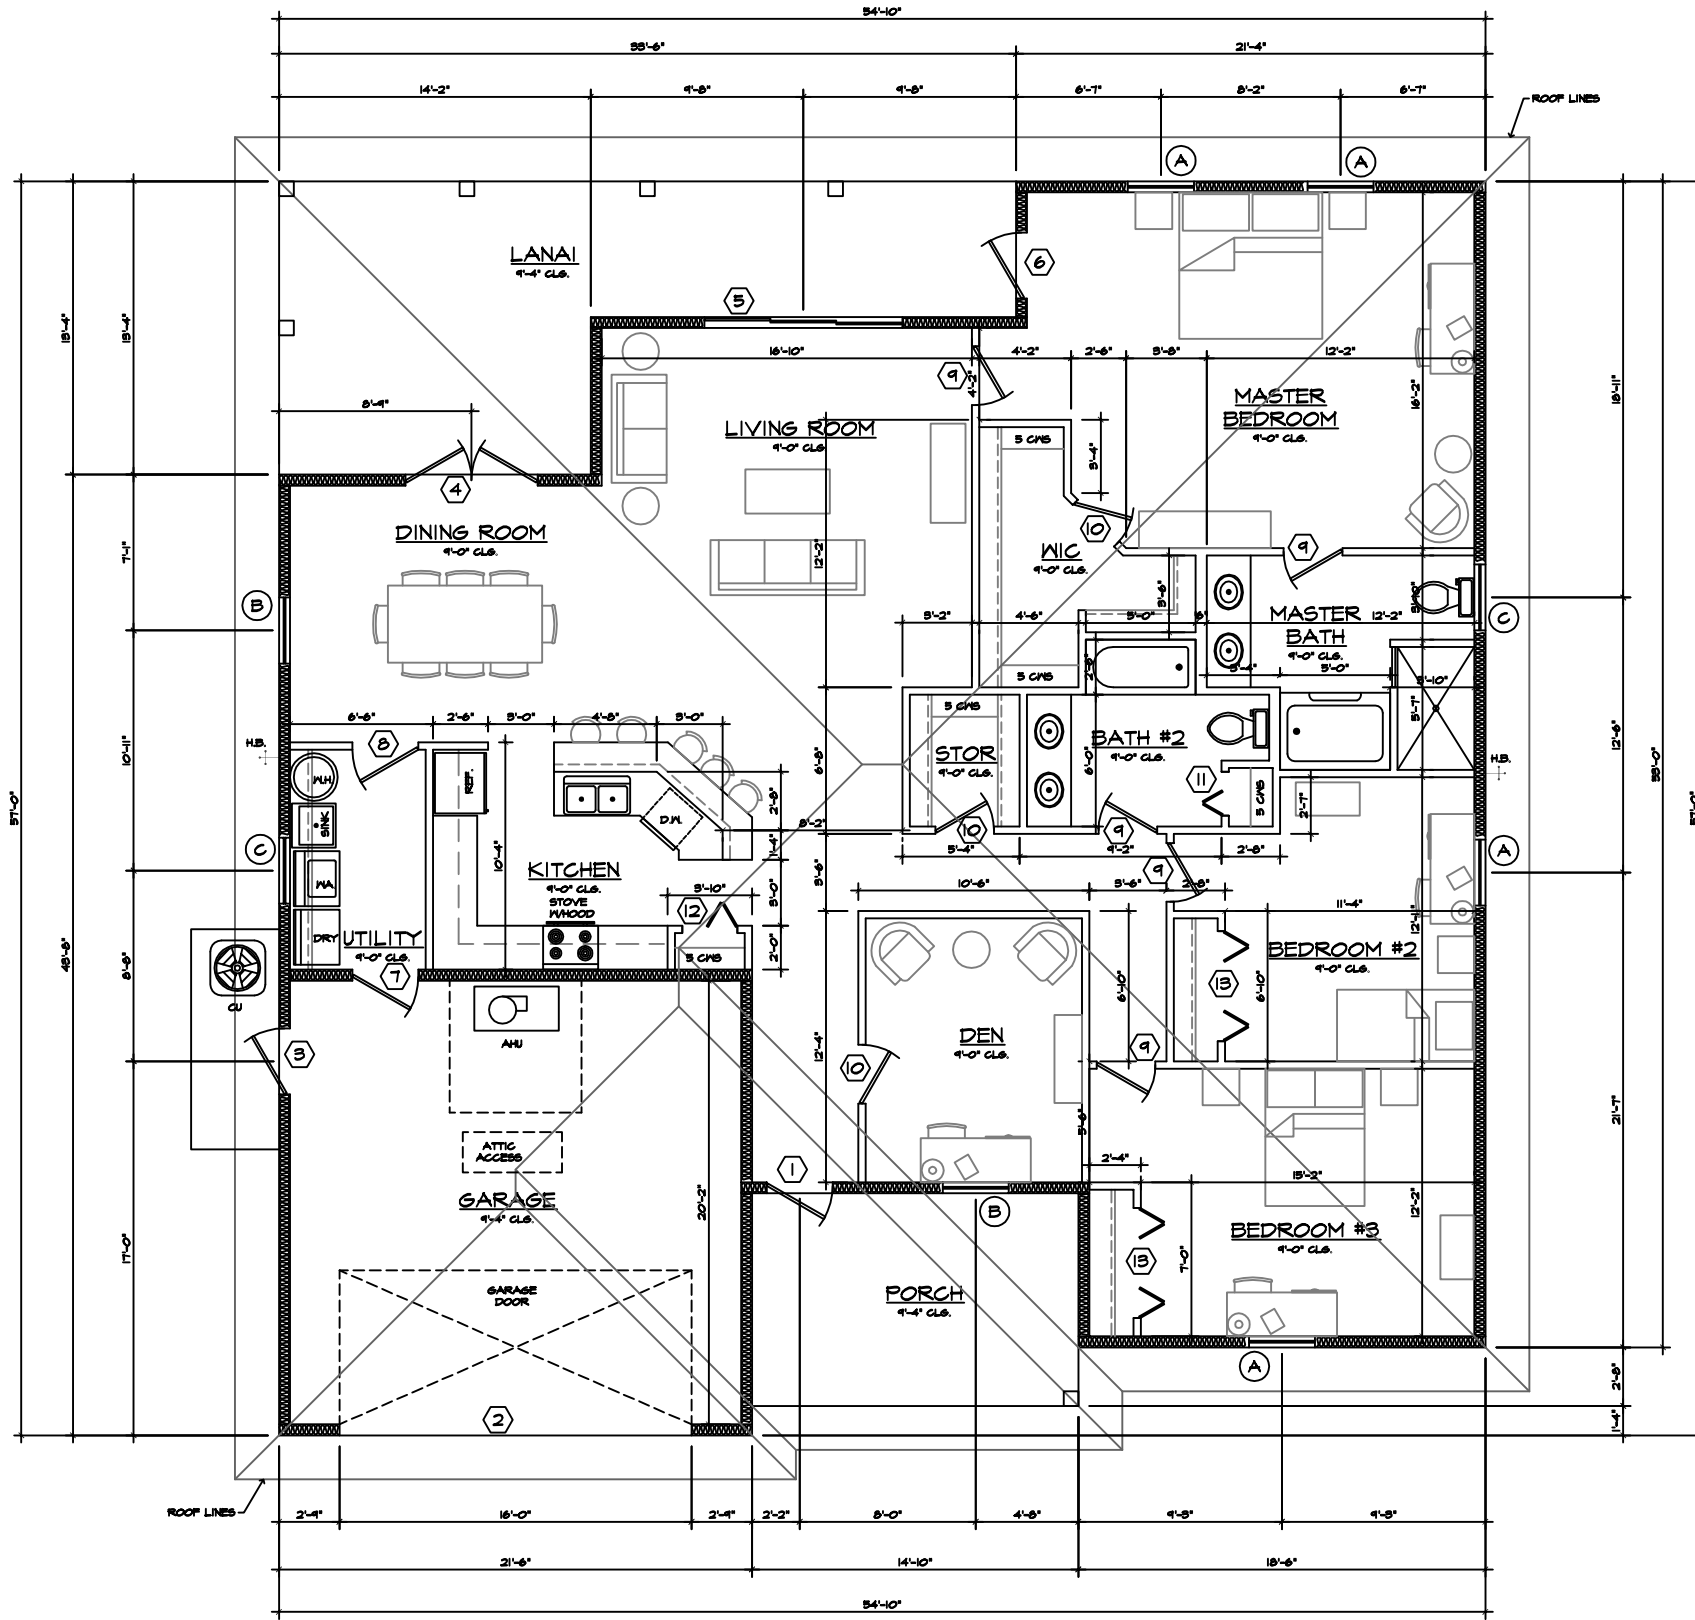

FLOOR PLAN

SCALE

1/4" = 1'-0"

A NEW RESIDENCE FOR:
MR & MRS JOHN SMITH
 123 ANYWHERE DRIVE
 CITY, STATE 0000


AUTOCAD DRAFTING PROVIDED BY:
 G. L. "CHIP" HARPER

LOCAL: (828) 388-1547 TOLL FREE: 1-866-411-1547
 FAX: (828) 388-6372 EMAIL: CHIP@HOT4CAD.COM
 WEB: WWW.HOT4CAD.COM

PLEASE TO PREPARE AND FOR CONSTRUCTION YOU SHOULD HAVE THESE PLANS CHECKED BY A LICENSED PROFESSIONAL FOR STRUCTURAL REQUIREMENTS, CODE AND ZONING COMPLIANCE.

DATE:
08-23-2007

SHEET:
A2

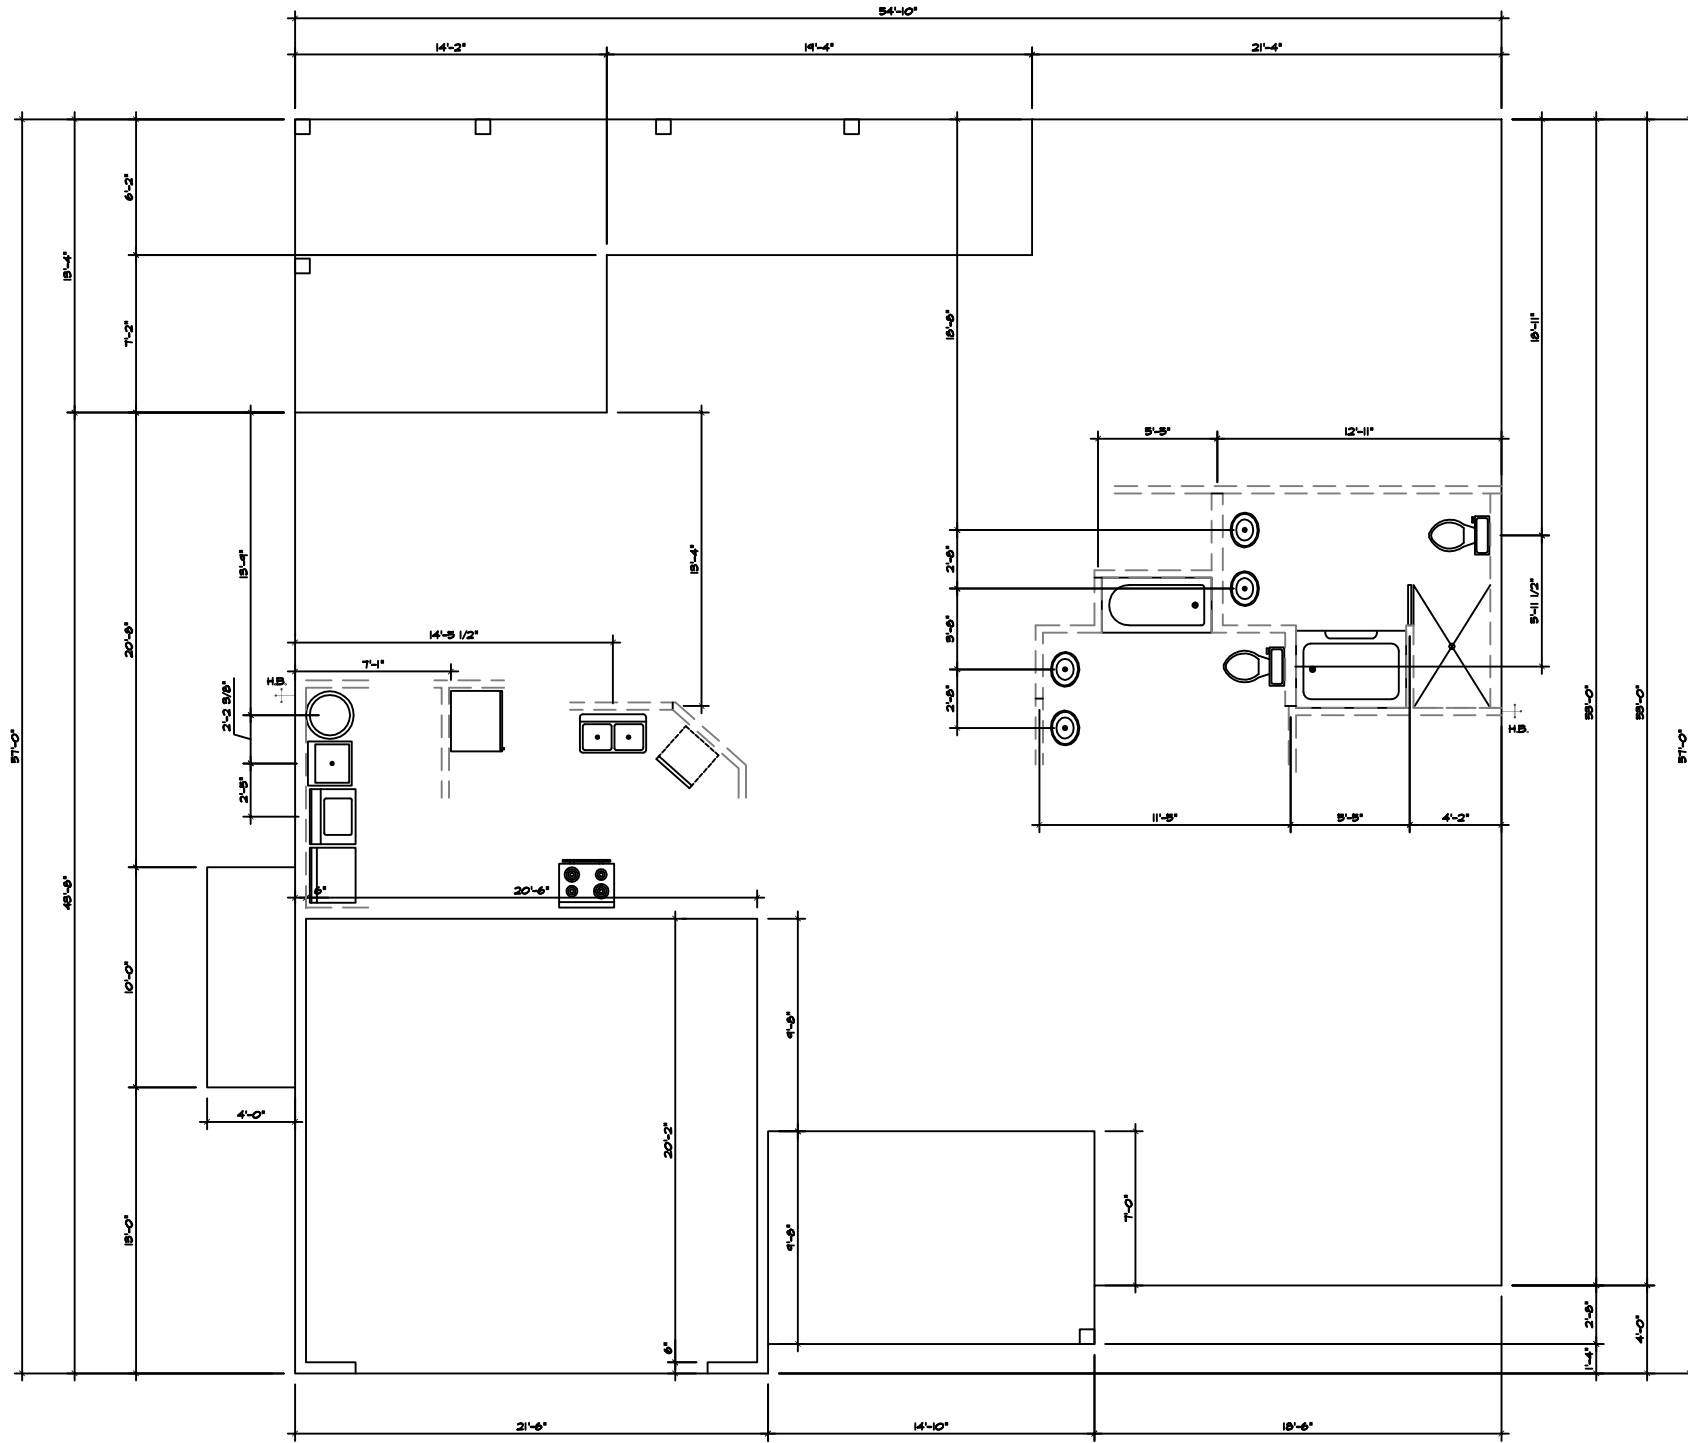

FOUNDATION PLAN

SCALE

1/4" = 1'-0"

AUTOCAD DRAFTING PROVIDED BY:
G. L. "CHIP" HARPER


LOCAL: (828) 388-1547 TOLL FREE: 1-866-411-1547
FAX: (828) 388-6372 EMAIL: CHIP@HOT4CAD.COM
WEB: WWW.HOT4CAD.COM

PLEASE TO PROVIDE AND FOR CONSTRUCTION YOU SHOULD HAVE THESE PLANS CHECKED BY A LICENSED PROFESSIONAL FOR STRUCTURAL REQUIREMENTS, CODE AND ZONING COMPLIANCE

DATE:
08-23-2007

SHEET:
A3

A NEW RESIDENCE FOR:
MR & MRS JOHN SMITH
123 ANYWHERE DRIVE
CITY, STATE 0000

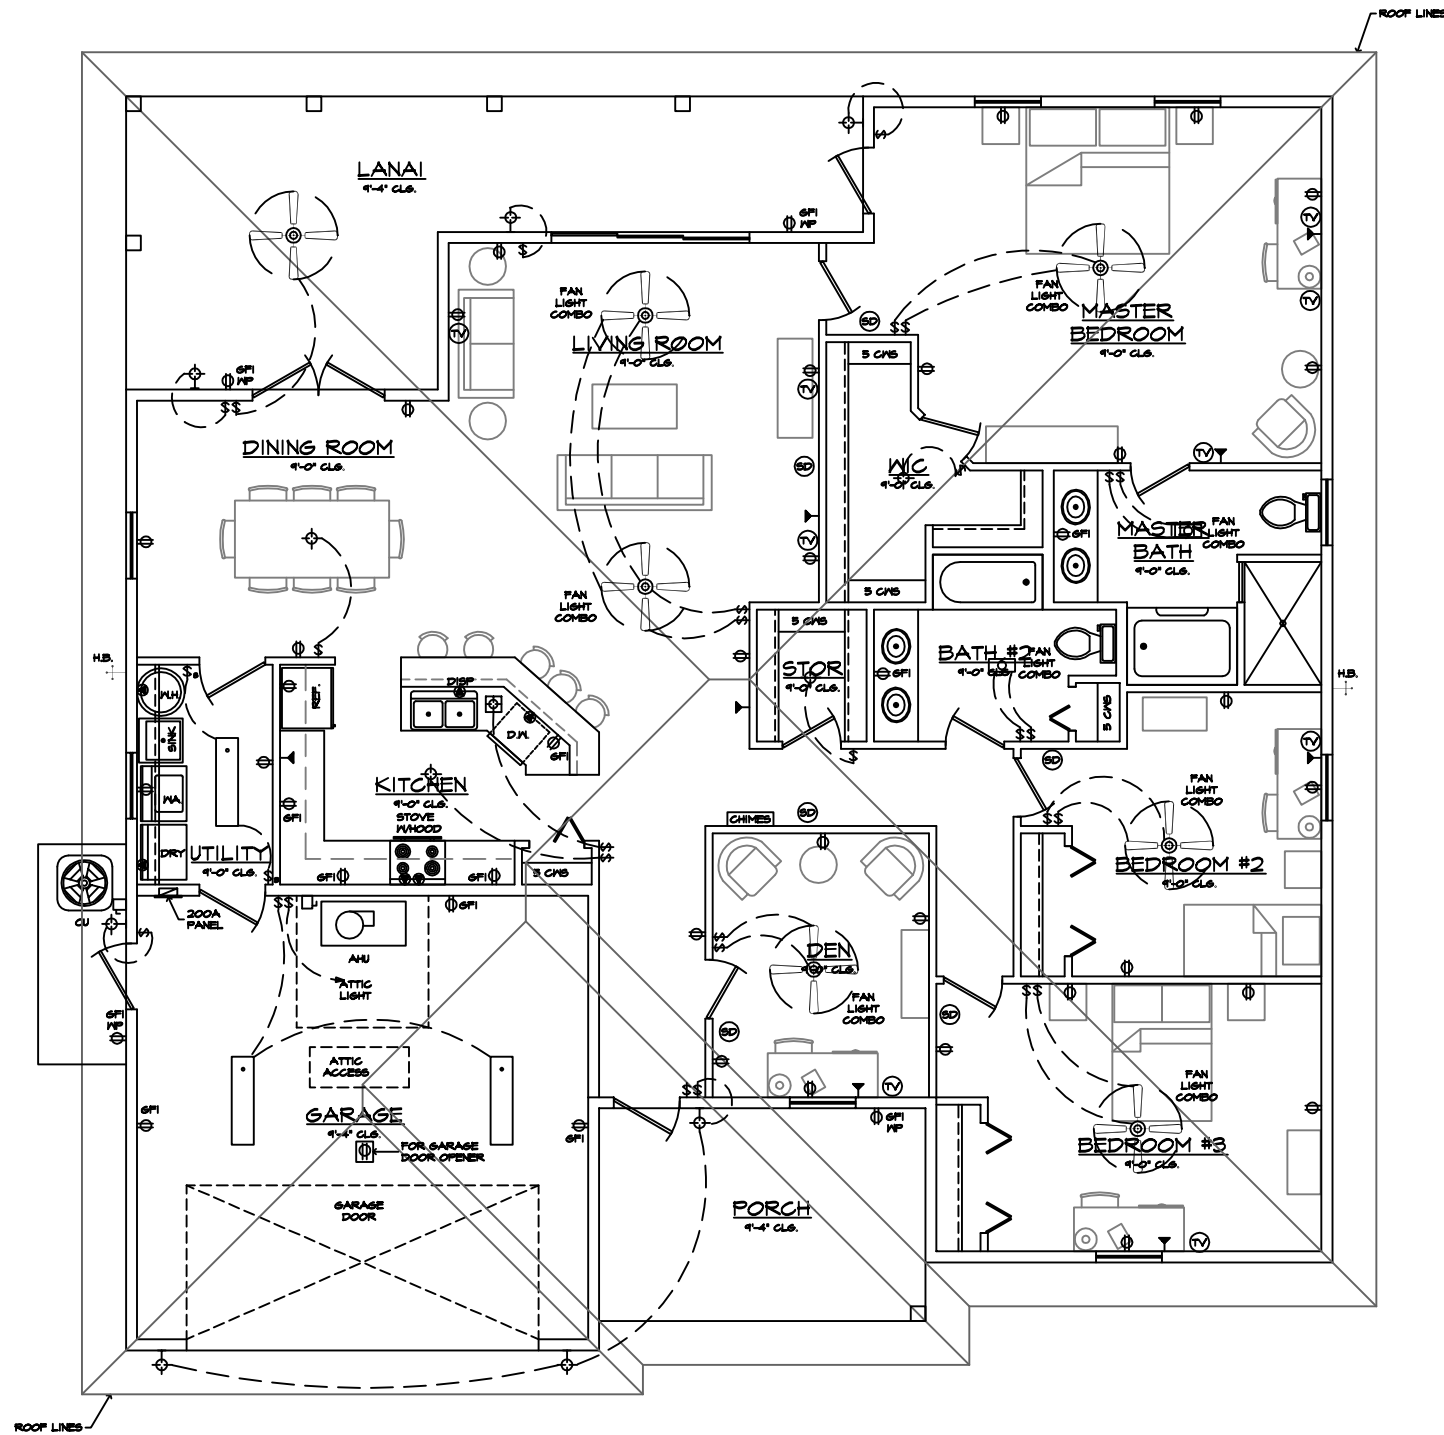

ELECTRICAL LEGEND

⊕	DUPLEX RECEPTACLE 120V 15A
⊕	DUPLEX OUTLET 120V 15A SPLIT WIRED
⊕	DUPLEX OUTLET OVER COUNTER AT 42"
⊕	SPECIAL PURPOSE OUTLET MATCH EQUIP PLUS
⊕	FLOOR OUTLET WITH FLOORING TRIM RING
⊕	DEDICATED COMPUTER OUTLET N/ ISOLATED GND
\$	SINGLE POLE SWITCH @ 148"
\$	SWITCH 3 WAY
\$	SWITCH WITH DIMMER
⊕	SURFACE MOUNTED CEILING LIGHT
⊕	HALL MOUNTED LIGHT
⊕	RECESSED CEILING LIGHT
⊕	SURFACE MOUNTED FLOOR 4' x 4 LAMP
⊕	SURFACE MTD. FLOOR STRIP FIXTURE
⊕	HALL SCORCE
⊕	FLOOD LIGHTS
⊕	TELEPHONE OUTLET
⊕	FUSED SWITCH
⊕	OUTLET FOR TELEVISION HOOKUP
⊕	PADDLE FAN AND LIGHT
⊕	SMOKE DETECTOR - DIRECT WIRED
⊕	CEILING MOUNTED EXHAUST FAN

ELECTRICAL PLAN

SCALE

1/4" = 1'-0"

A NEW RESIDENCE FOR:
MR & MRS JOHN SMITH
 123 ANYWHERE DRIVE
 CITY, STATE 0000

AUTOCAD DRAFTING PROVIDED BY:
 G. L. "CHIP" HARPER

LOCAL: (828) 388-1547 TOLL FREE: 1-866-411-1547
 FAX: (828) 388-6372 EMAIL: CHIP@HOT4CAD.COM
 WEB: WWW.HOT4CAD.COM

PLEASE TO PERFORMING AND/OR CONSTRUCTION YOU SHOULD HAVE THESE PLANS CHECKED BY A LICENSED PROFESSIONAL FOR STRUCTURAL REQUIREMENTS, CODE AND ZONING COMPLIANCE

DATE:
08-23-2007

SHEET:
A4

DOOR SCHEDULE									
DOOR NO.	SIZE	DOOR			FRAME		THRESHOLD	LOCKSET	REMARKS
		TYPE	MATERIAL	FINISH	MATERIAL	FINISH			
1	3'0" x 6'8"	HSG.						KEYED	FRONT ENTRY
2	16'0" x 7'0"	HSG.						KEYED	GARAGE ROLL UP
3	3'0" x 6'8"	HSG.						KEYED	GARAGE SIDE ENTRY
4	(PR) 3'0" x 6'8"	HSG.						YES	FR FRENCH DOORS
5	9'0" x 6'8"	HSG.						YES	SLIDING GLASS DOORS
6	3'0" x 6'8"	HSG.						YES	FRENCH DOOR
7	3'0" x 6'8"	HSG.						YES	GARAGE TO UTILITY
8	3'0" x 6'8"	HSG.						NO	UTILITY DOOR
9	2'8" x 6'8"	HSG.						PRIVACY	BATH & BEDROOMS
10	2'8" x 6'8"	HSG.						NO	DEN & STORAGE
11	2'0" x 6'8"	BF						NO	CLOSET
12	2'0" x 6'8"	BF						NO	PANTRY
13	(PR) 2'6" x 6'8"	BF						NO	CLOSET

LEGEND:

F = FLUSH	HSG. = HINGED SWING DOOR	FR = FRENCH DOOR	INS = INSULATED
SC = SOLID CORE	SLDG.GL. = SLIDING GLASS DOOR	LYR = LOUVERED	P = PAINTED
HC = HOLLOW CORE	ATR = ATRIUM(GL DR W/SIDELITE)	WD = WOOD	ST = STAINED
GL = GLASS	BF = BI-FOLDING	VIN = VINYL	PRF = PREFINISHED
PNL = PANEL	OHD = OVERHEAD DOOR	MET = METAL	
	ASG = AUTOMATIC SLIDING GLASS	MAS = MASONITE	

WINDOW SCHEDULE					
MARK	SIZE	TYPE	MATERIAL	GLASS	REMARKS
A	* 3x5'				EGRESS REQUIREMENT
B	* 3x5'				
C	* 3x2'6"				

* WINDOW SIZES ARE APPROXIMATE AS THEY VARY PER MANUFACTURER. VERIFY MANUFACTURERS DIMENSIONS BASED ON CUSTOMER SELECTION.

SCHEDULES

SCALE

1/4" = 1'-0"

A NEW RESIDENCE FOR:
MR & MRS JOHN SMITH
 123 ANYWHERE DRIVE
 CITY, STATE 0000

AUTOCAD DRAFTING PROVIDED BY:
 G. L. "CHIP" HARPER

LOCAL: (828) 388-1547 TOLL FREE: 1-866-411-1547
 FAX: (828) 388-6372 EMAIL: CHIP@HOT4CAD.COM
 WEB: WWW.HOT4CAD.COM

PRICE TO PREPARE AND FOR CONSTRUCTION YOU SHOULD HAVE THESE PLANS CHECKED BY A LICENSED PROFESSIONAL FOR STRUCTURAL REQUIREMENTS, CODE AND ZONING COMPLIANCE

DATE:
08-23-2007

SHEET:
A5