

FIRST FLOOR PLAN - NOTED

SCALE

1/4" = 1'-0"


AUTOCAD DRAFTING PROVIDED BY:
G. L. "CHIP" HARPER

LOCAL: (828) 389-1547 TOLL FREE: 1-866-411-1547
FAX: (828) 389-6372 EMAIL: CHIP@HOT4CAD.COM
WEB: WWW.HOT4CAD.COM

PRIOR TO PERMITTING AND/OR CONSTRUCTION YOU SHOULD HAVE THESE PLANS CHECKED BY A LICENSED PROFESSIONAL FOR STRUCTURAL REQUIREMENTS, CODE AND ZONING COMPLIANCE

DATE:
04-20-2009

SHEET:
A-03

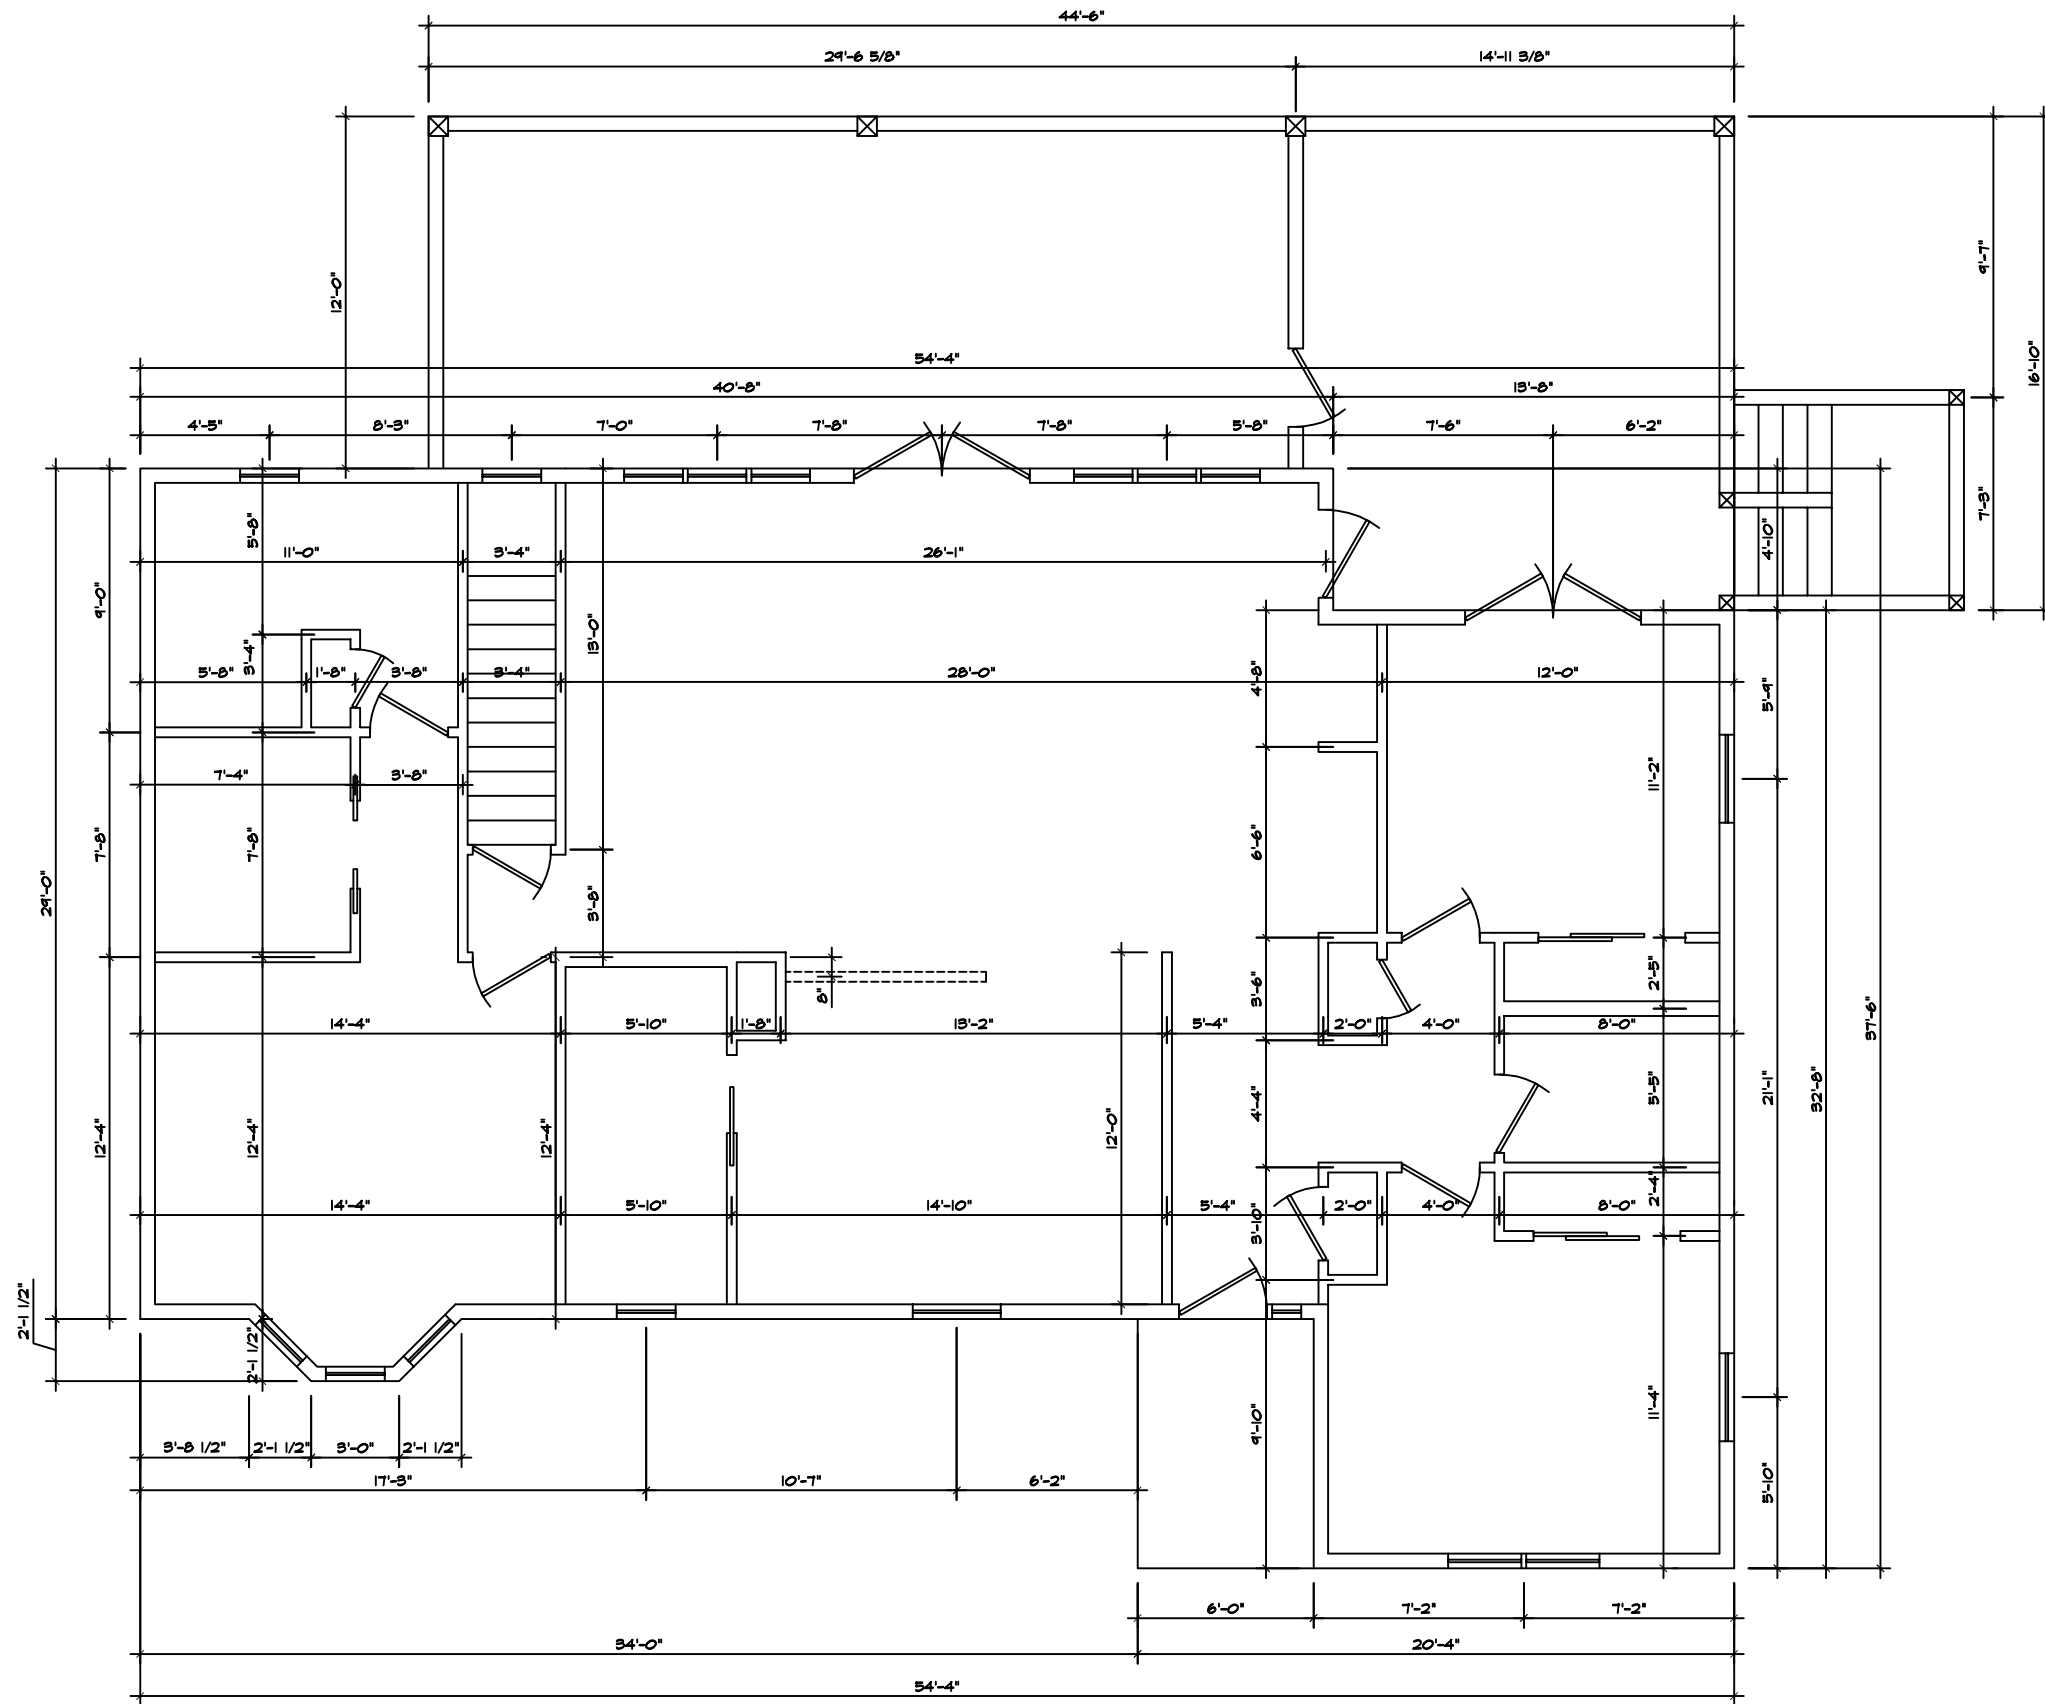

FIRST FLOOR PLAN - DIMENSIONED

SCALE

1/4" = 1'-0"


AUTOCAD DRAFTING PROVIDED BY:
G. L. "CHIP" HARPER

LOCAL: (828) 389-1547 TOLL FREE: 1-866-411-1547
FAX: (828) 389-6372 EMAIL: CHIP@HOT4CAD.COM
WEB: WWW.HOT4CAD.COM

PRIOR TO PERMITTING AND/OR CONSTRUCTION YOU SHOULD HAVE THESE PLANS CHECKED BY A LICENSED PROFESSIONAL FOR STRUCTURAL REQUIREMENTS, CODE AND ZONING COMPLIANCE

DATE:
04-20-2009


SHEET:
A-04

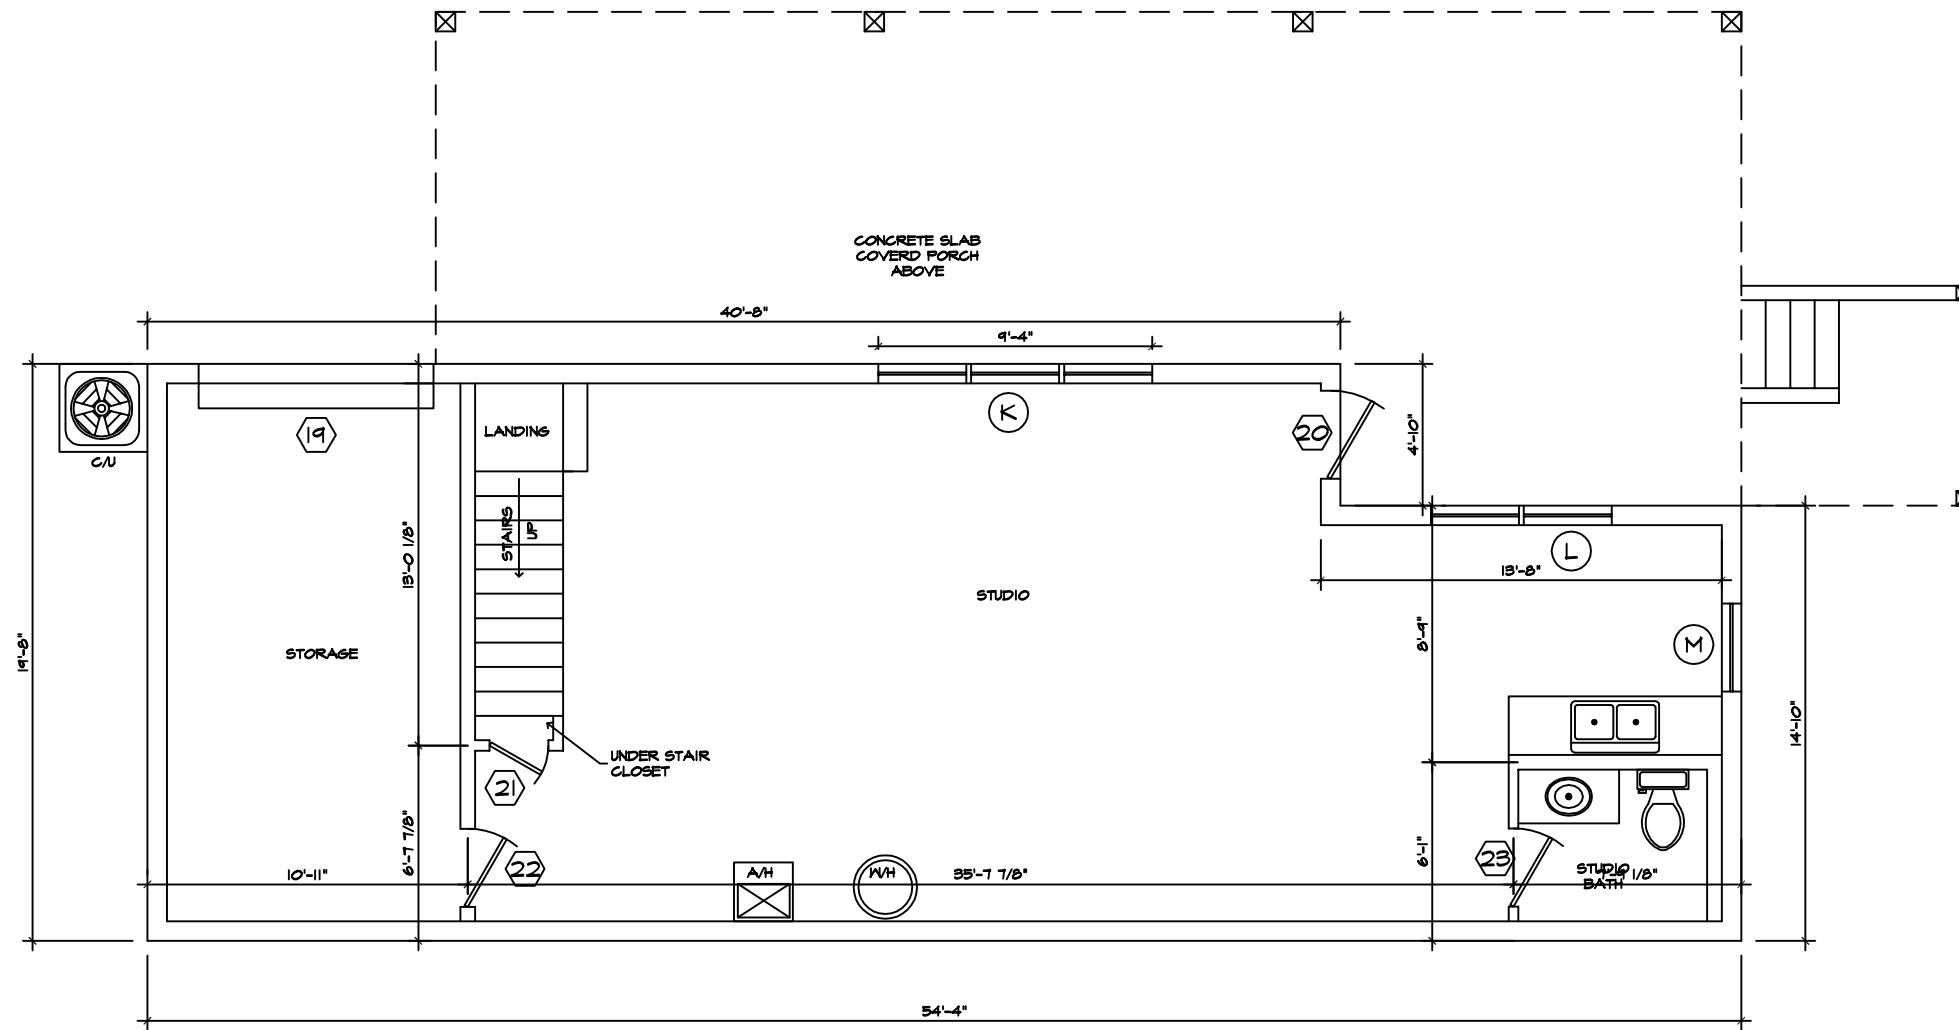

BASEMENT FLOOR PLAN

SCALE

1/4" = 1'-0"

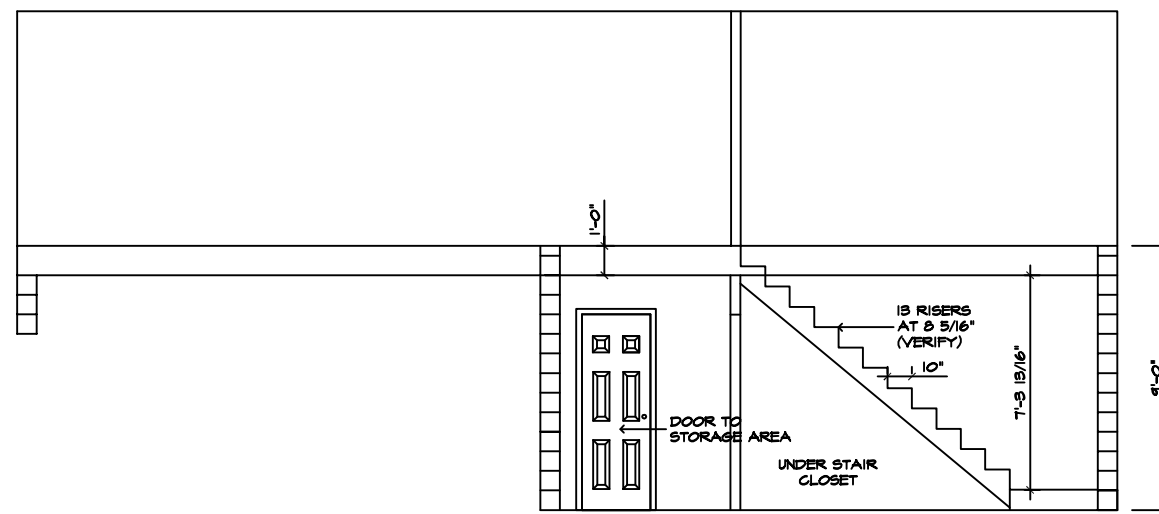

BASEMENT RIGHT ELEVATION

SCALE

1/4" = 1'-0"

AUTOCAD DRAFTING PROVIDED BY:
G. L. "CHIP" HARPER


LOCAL: (828) 389-1547 TOLL FREE: 1-866-411-1547
FAX: (828) 389-6372 EMAIL: CHIP@HOT4CAD.COM
WEB: WWW.HOT4CAD.COM

PRIOR TO PERMITTING AND/OR CONSTRUCTION YOU SHOULD HAVE THESE PLANS CHECKED BY A LICENSED PROFESSIONAL FOR STRUCTURAL REQUIREMENTS, CODE AND ZONING COMPLIANCE

DATE:
04-20-2009

SHEET:
A-05

05 OF 18

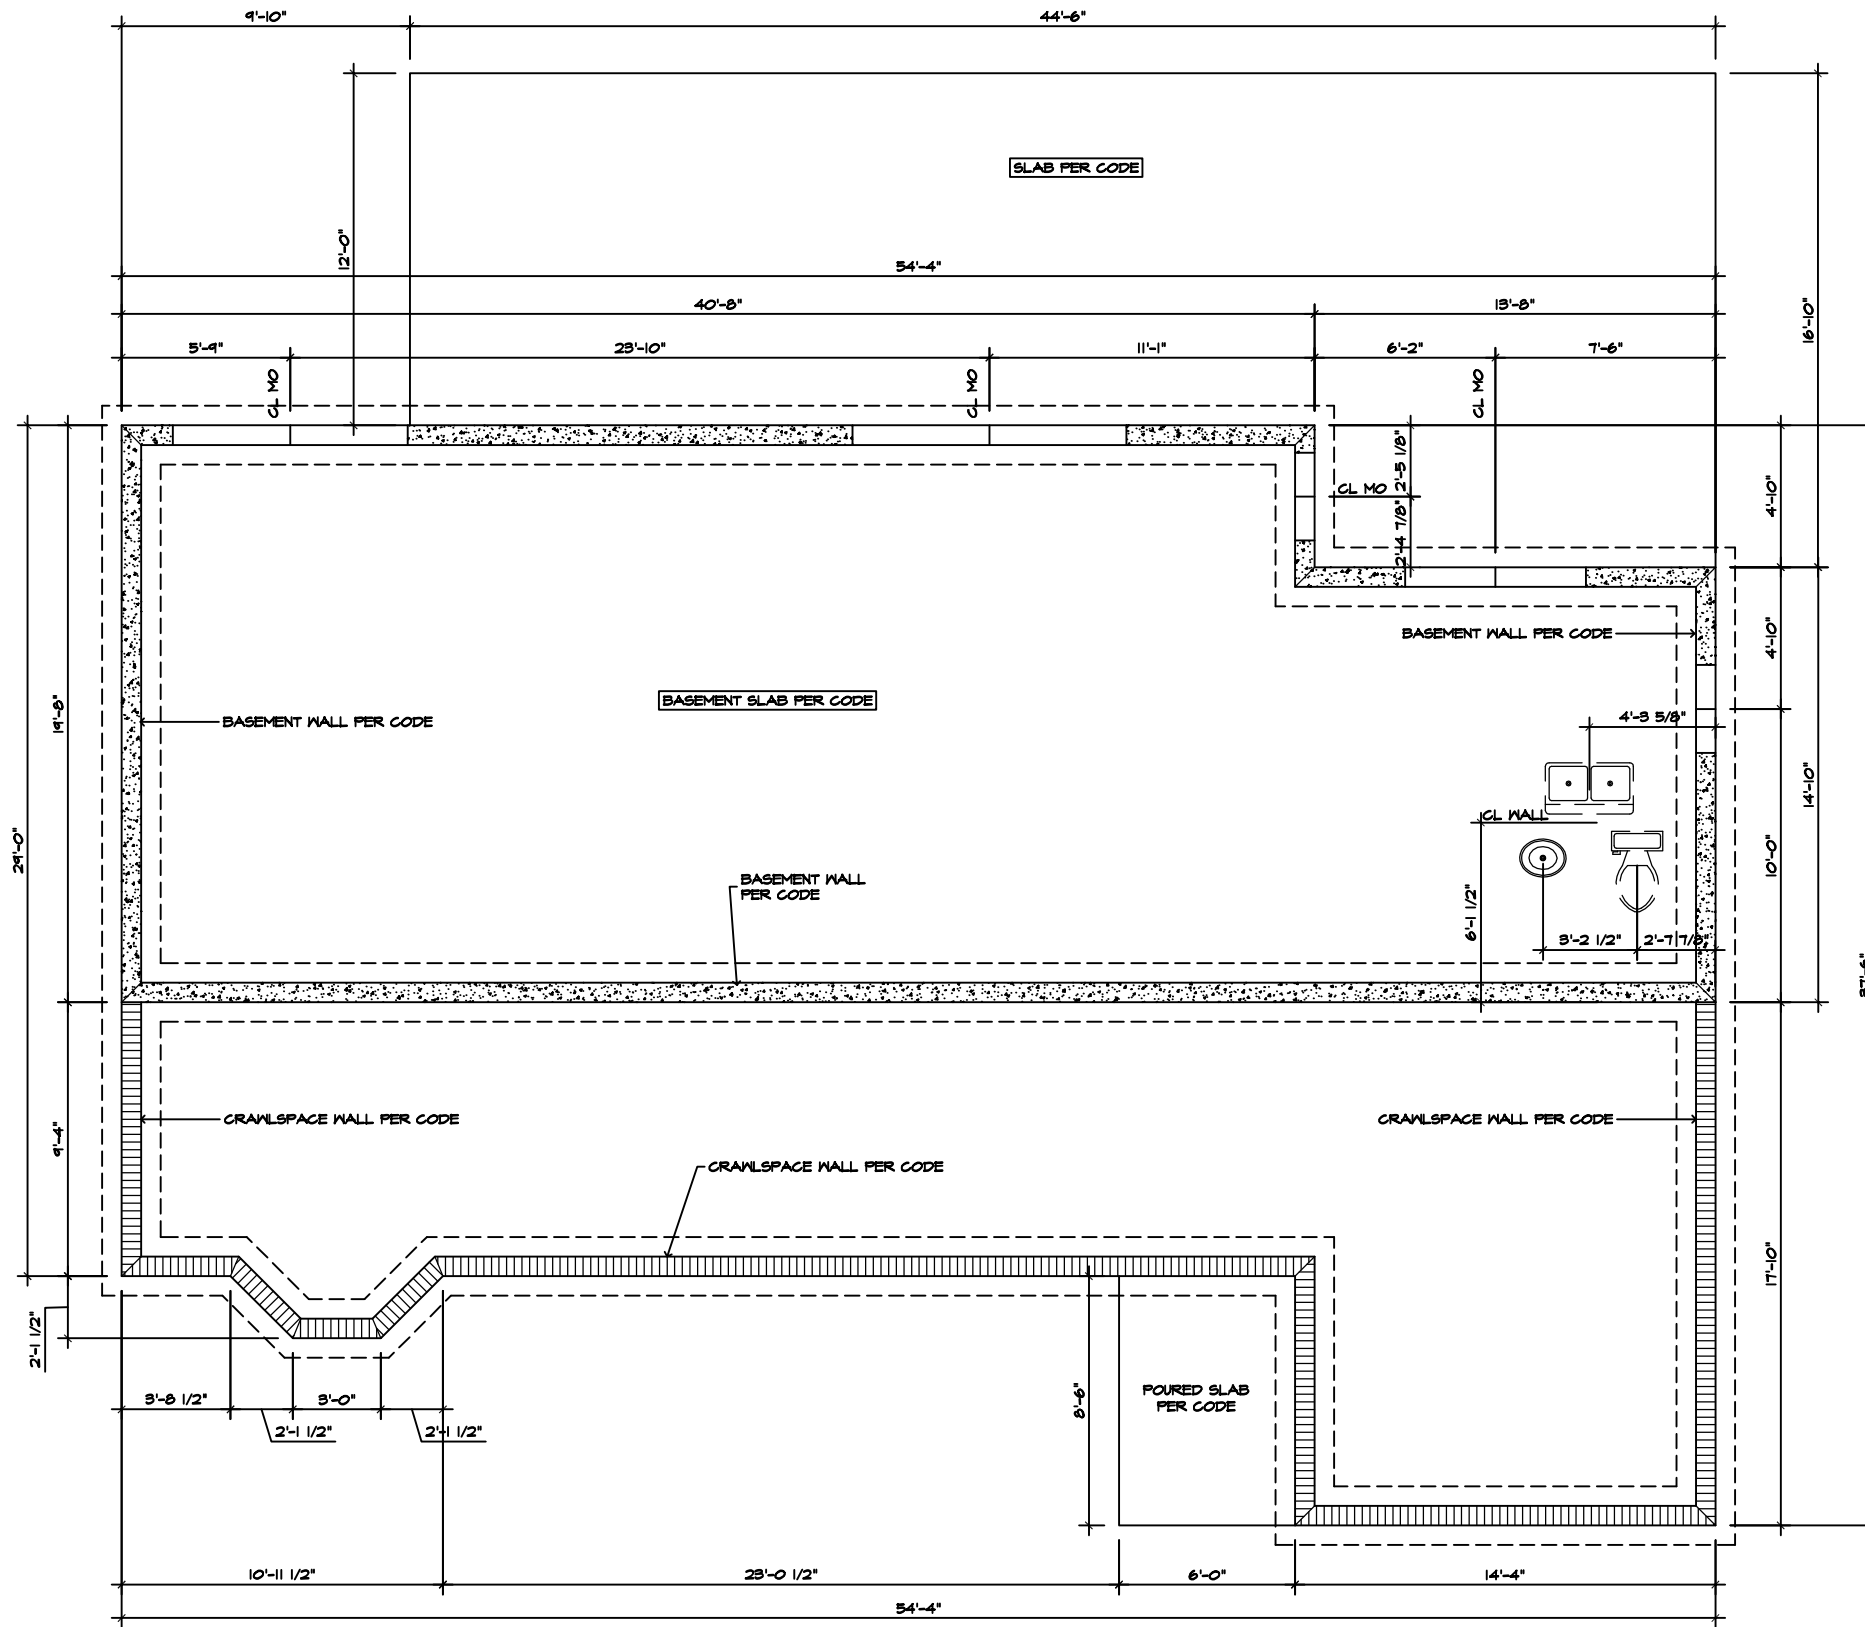

FOUNDATION PLAN

SCALE

1/4" = 1'-0"

AUTOCAD DRAFTING PROVIDED BY:
G. L. "CHIP" HARPER


LOCAL: (828) 389-1547 TOLL FREE: 1-866-411-1547
FAX: (828) 389-6372 EMAIL: CHIP@HOT4CAD.COM
WEB: WWW.HOT4CAD.COM

PRIOR TO PERMITTING AND/OR CONSTRUCTION YOU SHOULD HAVE THESE PLANS CHECKED BY A LICENSED PROFESSIONAL FOR STRUCTURAL REQUIREMENTS, CODE AND ZONING COMPLIANCE

DATE:
04-20-2009

SHEET:
A-06

06 OF 18

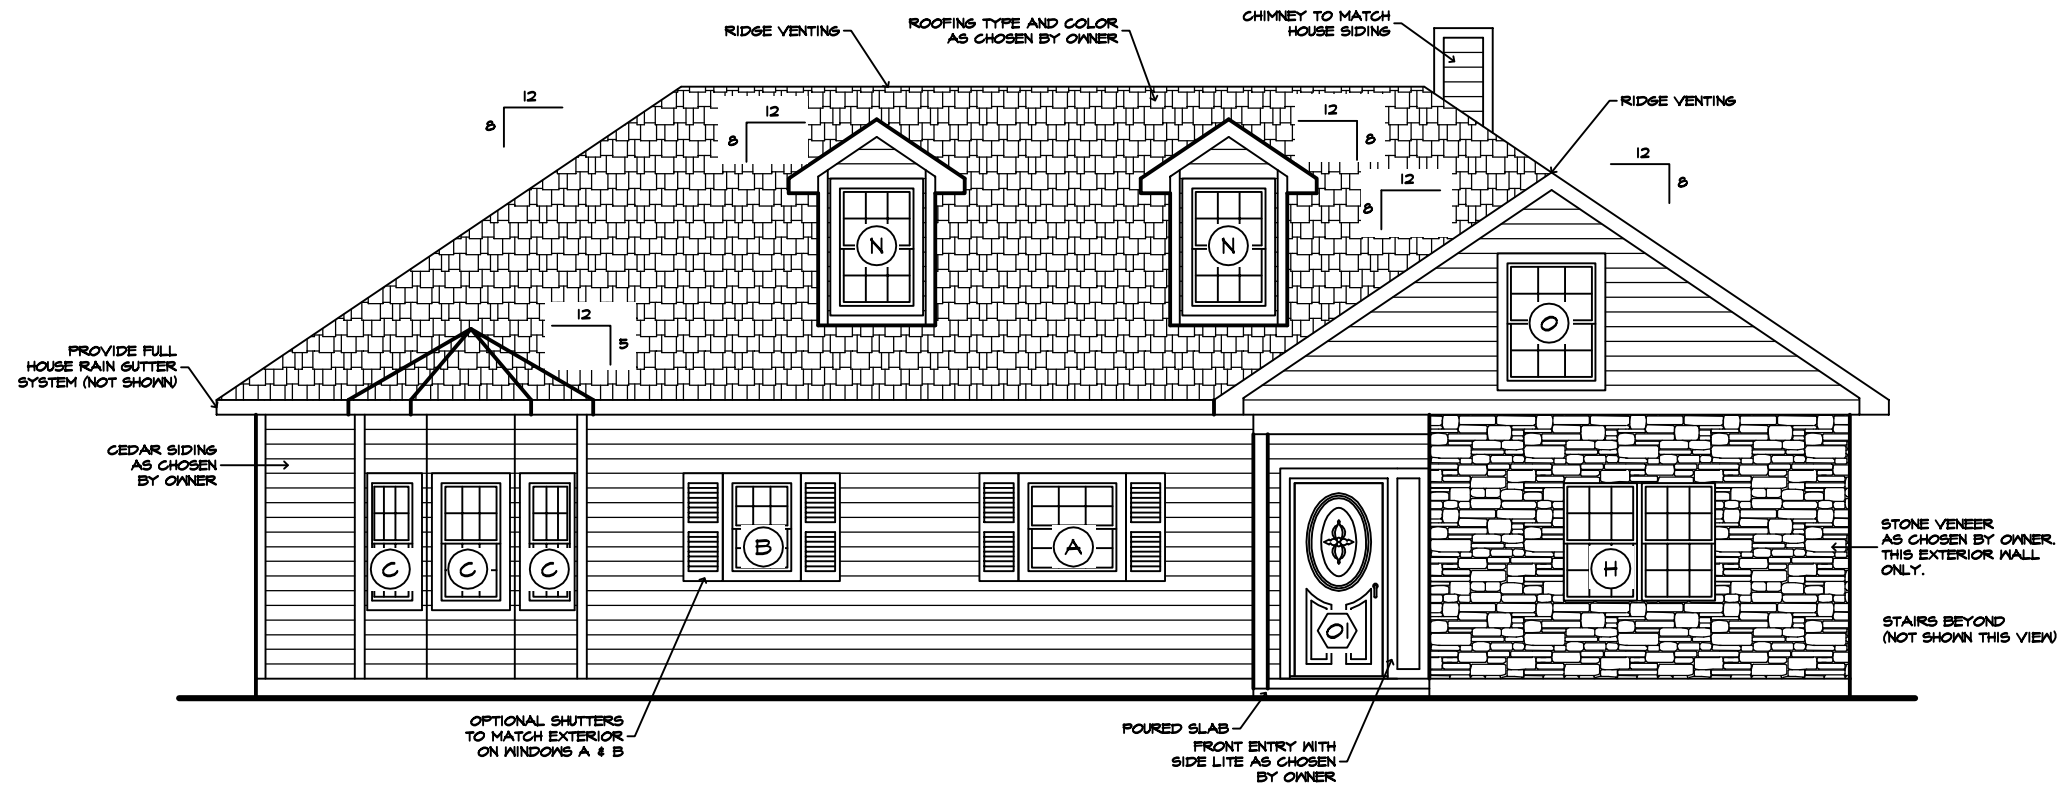

FRONT ELEVATION

SCALE

1/4" = 1'-0"

AUTOCAD DRAFTING PROVIDED BY:
G. L. "CHIP" HARPER


LOCAL: (828) 389-1547 TOLL FREE: 1-866-411-1547
FAX: (828) 389-6372 EMAIL: CHIP@HOT4CAD.COM
WEB: WWW.HOT4CAD.COM

PRIOR TO PERMITTING AND/OR CONSTRUCTION YOU SHOULD HAVE THESE PLANS CHECKED BY A LICENSED PROFESSIONAL FOR STRUCTURAL REQUIREMENTS, CODE AND ZONING COMPLIANCE

DATE:
04-20-2009

SHEET:
A-08

08 OF 18

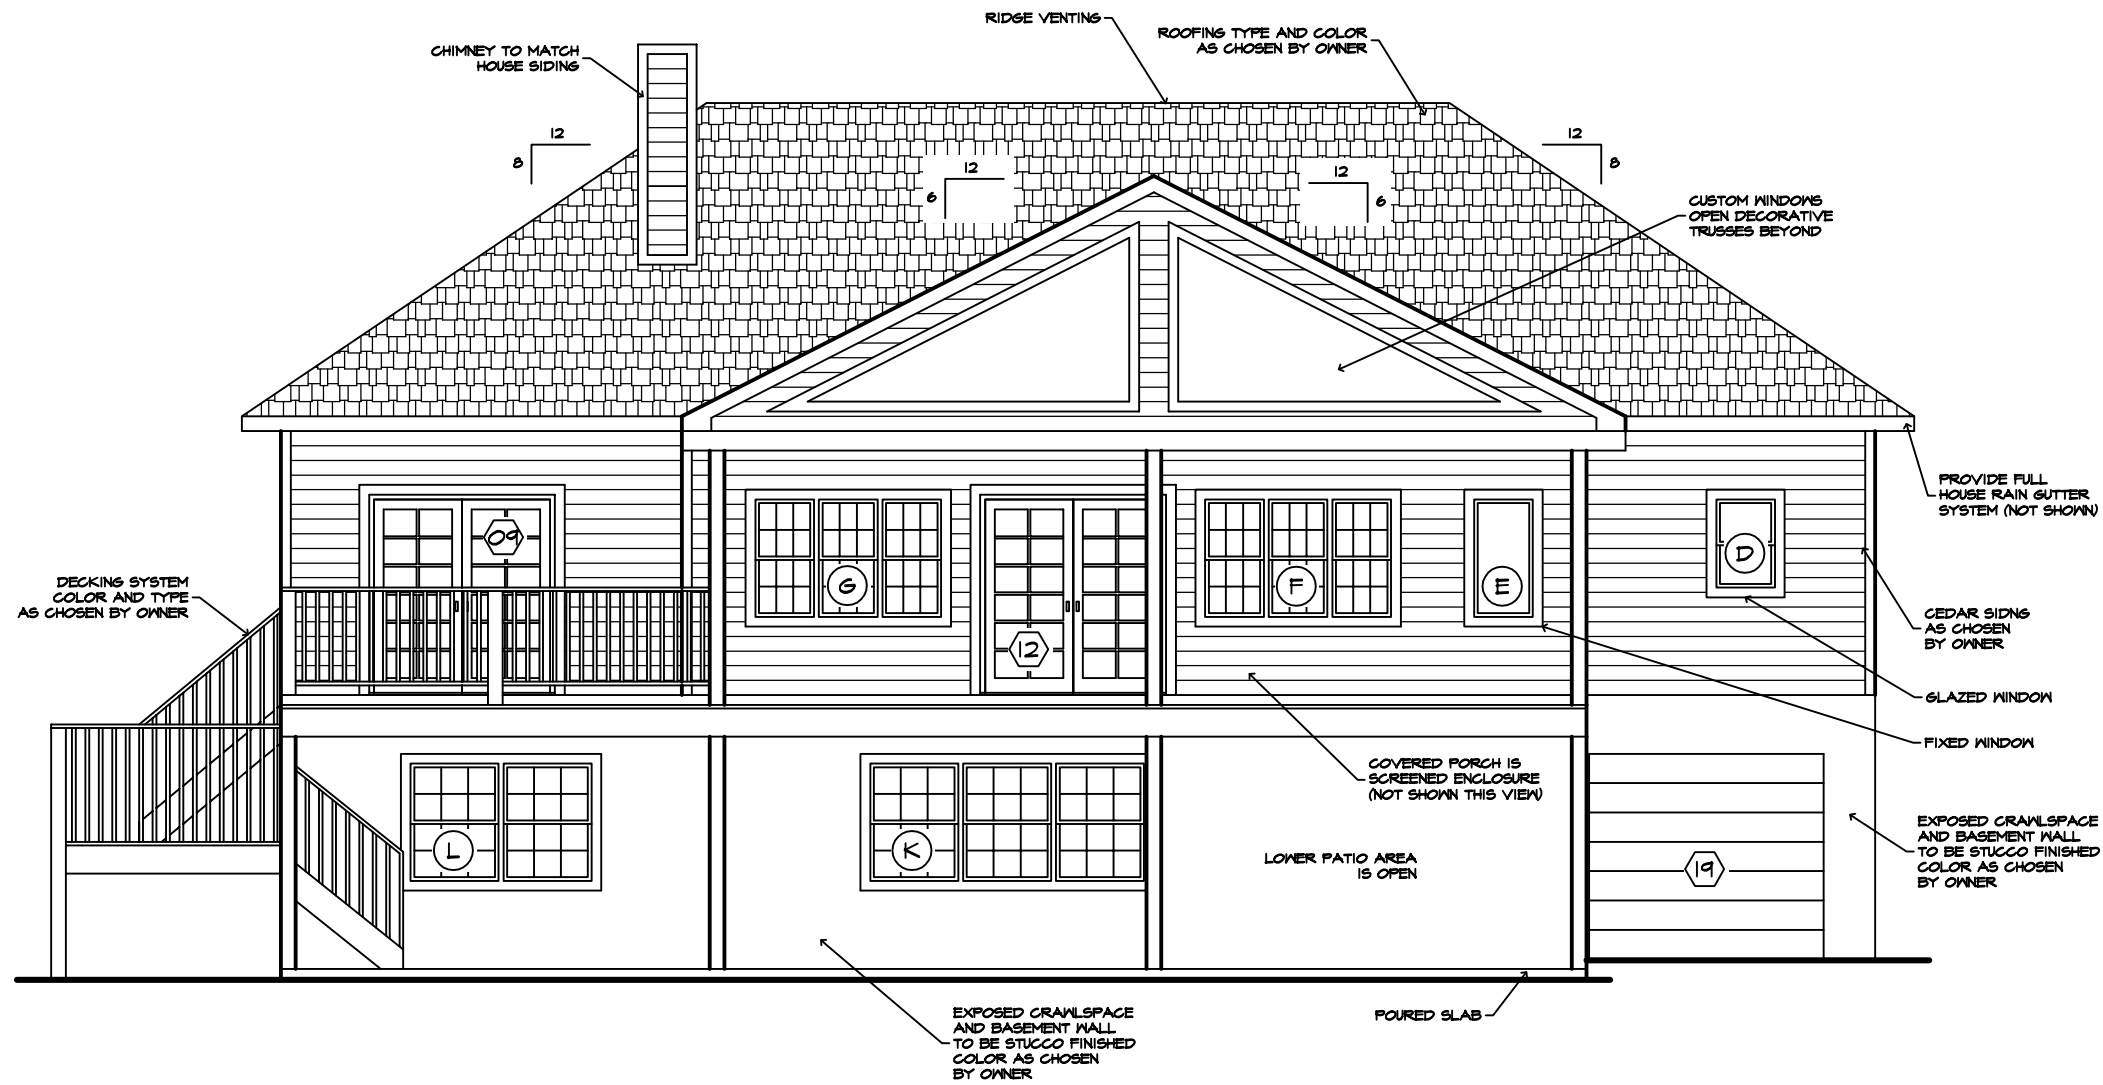

REAR ELEVATION

SCALE

1/4" = 1'-0"


AUTOCAD DRAFTING PROVIDED BY:
G. L. "CHIP" HARPER

LOCAL: (828) 389-1547 TOLL FREE: 1-866-411-1547
FAX: (828) 389-6372 EMAIL: CHIP@HOT4CAD.COM
WEB: WWW.HOT4CAD.COM

PRIOR TO PERMITTING AND/OR CONSTRUCTION YOU SHOULD HAVE THESE PLANS CHECKED BY A LICENSED PROFESSIONAL FOR STRUCTURAL REQUIREMENTS, CODE AND ZONING COMPLIANCE

DATE:
04-20-2009

SHEET:
A-09

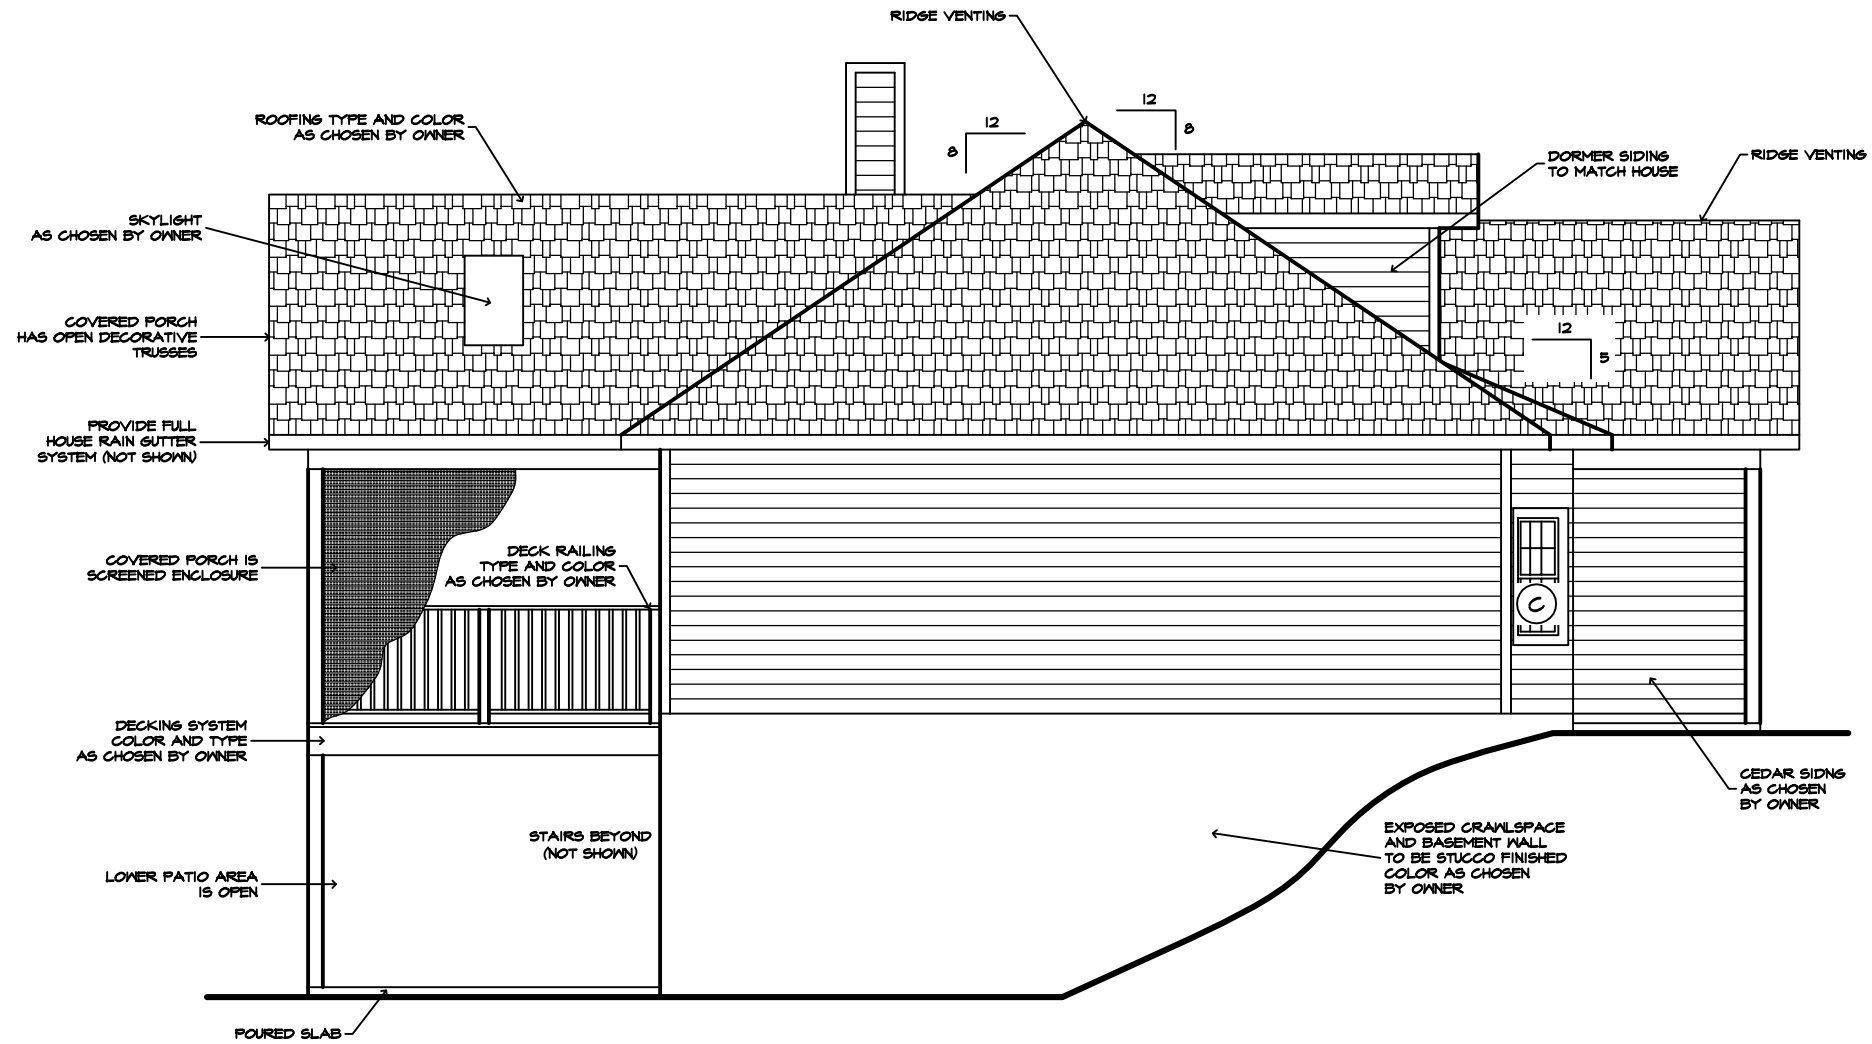

LEFT ELEVATION

SCALE

1/4" = 1'-0"


AUTOCAD DRAFTING PROVIDED BY:
G. L. "CHIP" HARPER

LOCAL: (828) 389-1547 TOLL FREE: 1-866-411-1547
FAX: (828) 389-6372 EMAIL: CHIP@HOT4CAD.COM
WEB: WWW.HOT4CAD.COM

PRIOR TO PERMITTING AND/OR CONSTRUCTION YOU SHOULD HAVE THESE PLANS CHECKED BY A LICENSED PROFESSIONAL FOR STRUCTURAL REQUIREMENTS, CODE AND ZONING COMPLIANCE

DATE:
04-20-2009

SHEET:
A-10

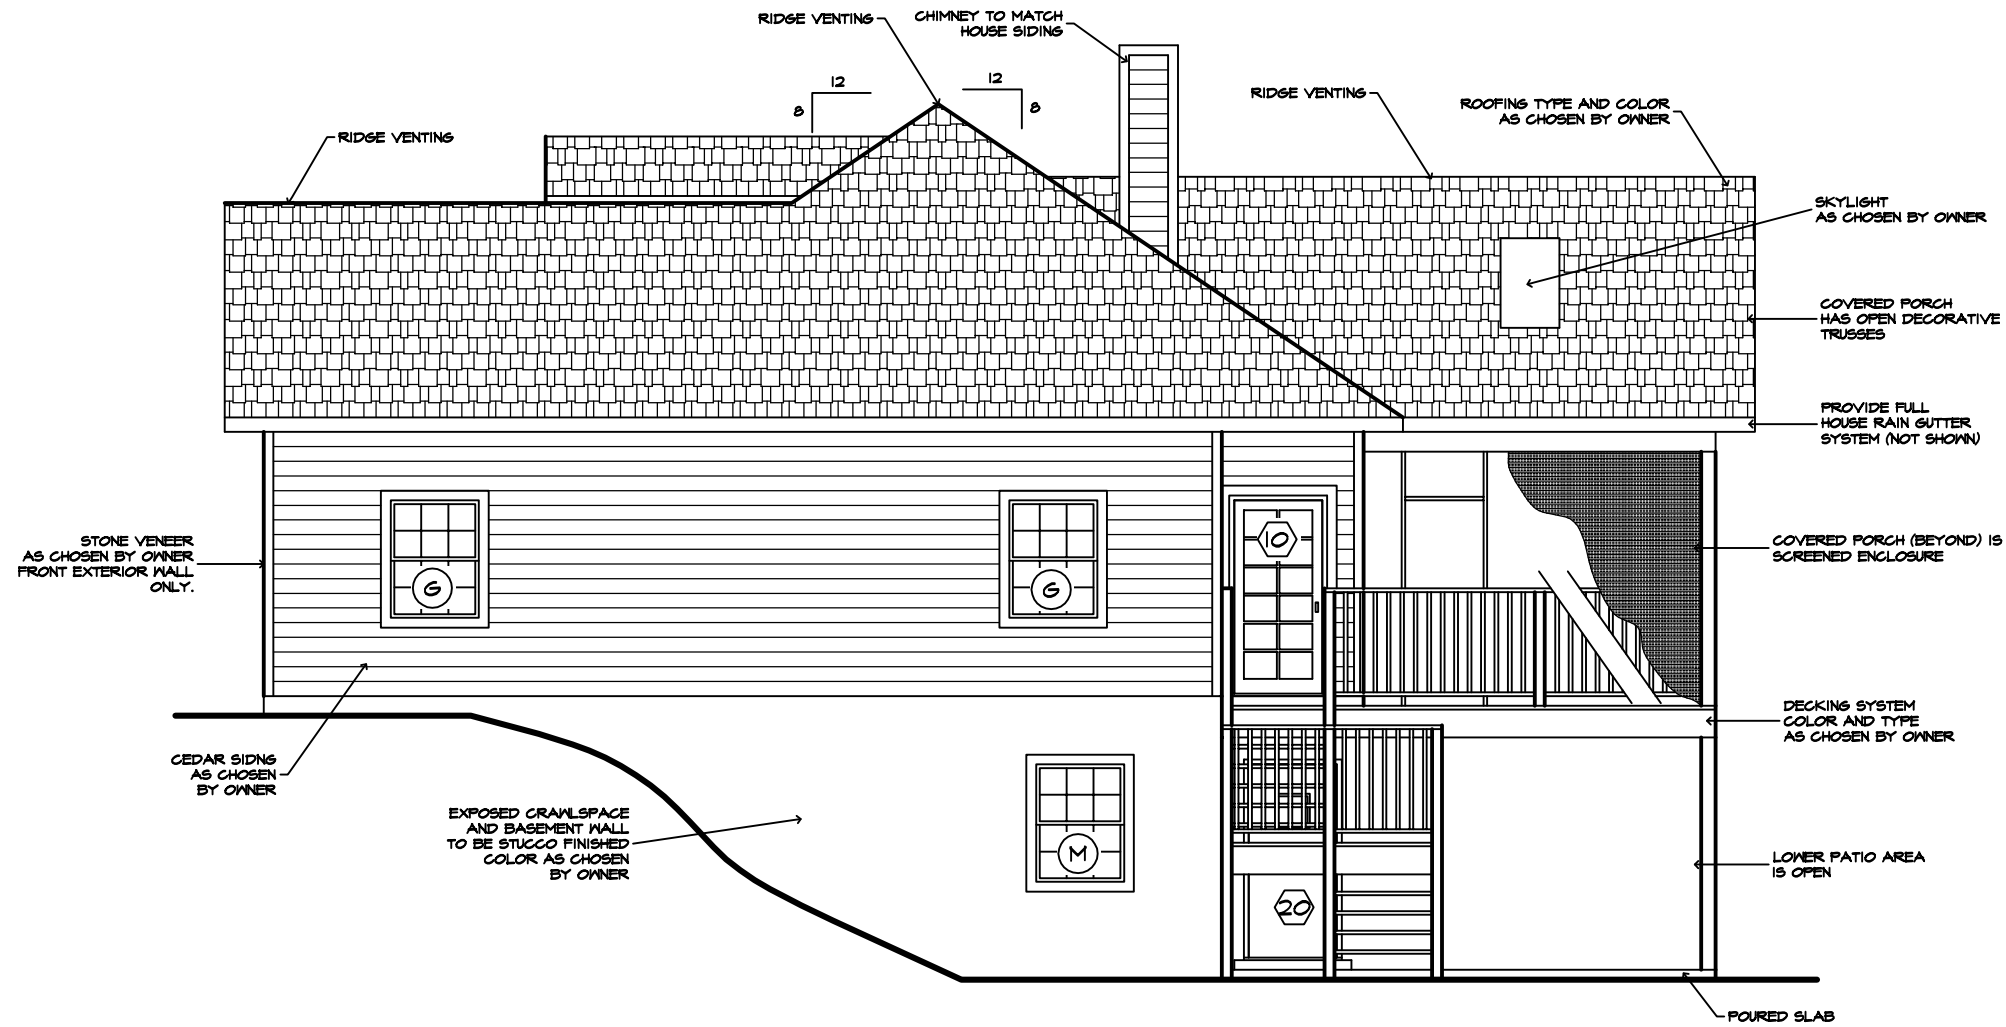

RIGHT ELEVATION

SCALE

1/4" = 1'-0"


AUTOCAD DRAFTING PROVIDED BY:
G. L. "CHIP" HARPER

LOCAL: (828) 389-1547 TOLL FREE: 1-866-411-1547
FAX: (828) 389-6372 EMAIL: CHIP@HOT4CAD.COM
WEB: WWW.HOT4CAD.COM

PRIOR TO PERMITTING AND/OR CONSTRUCTION YOU SHOULD HAVE THESE PLANS CHECKED BY A LICENSED PROFESSIONAL FOR STRUCTURAL REQUIREMENTS, CODE AND ZONING COMPLIANCE

DATE:
04-20-2009

SHEET:
A-11

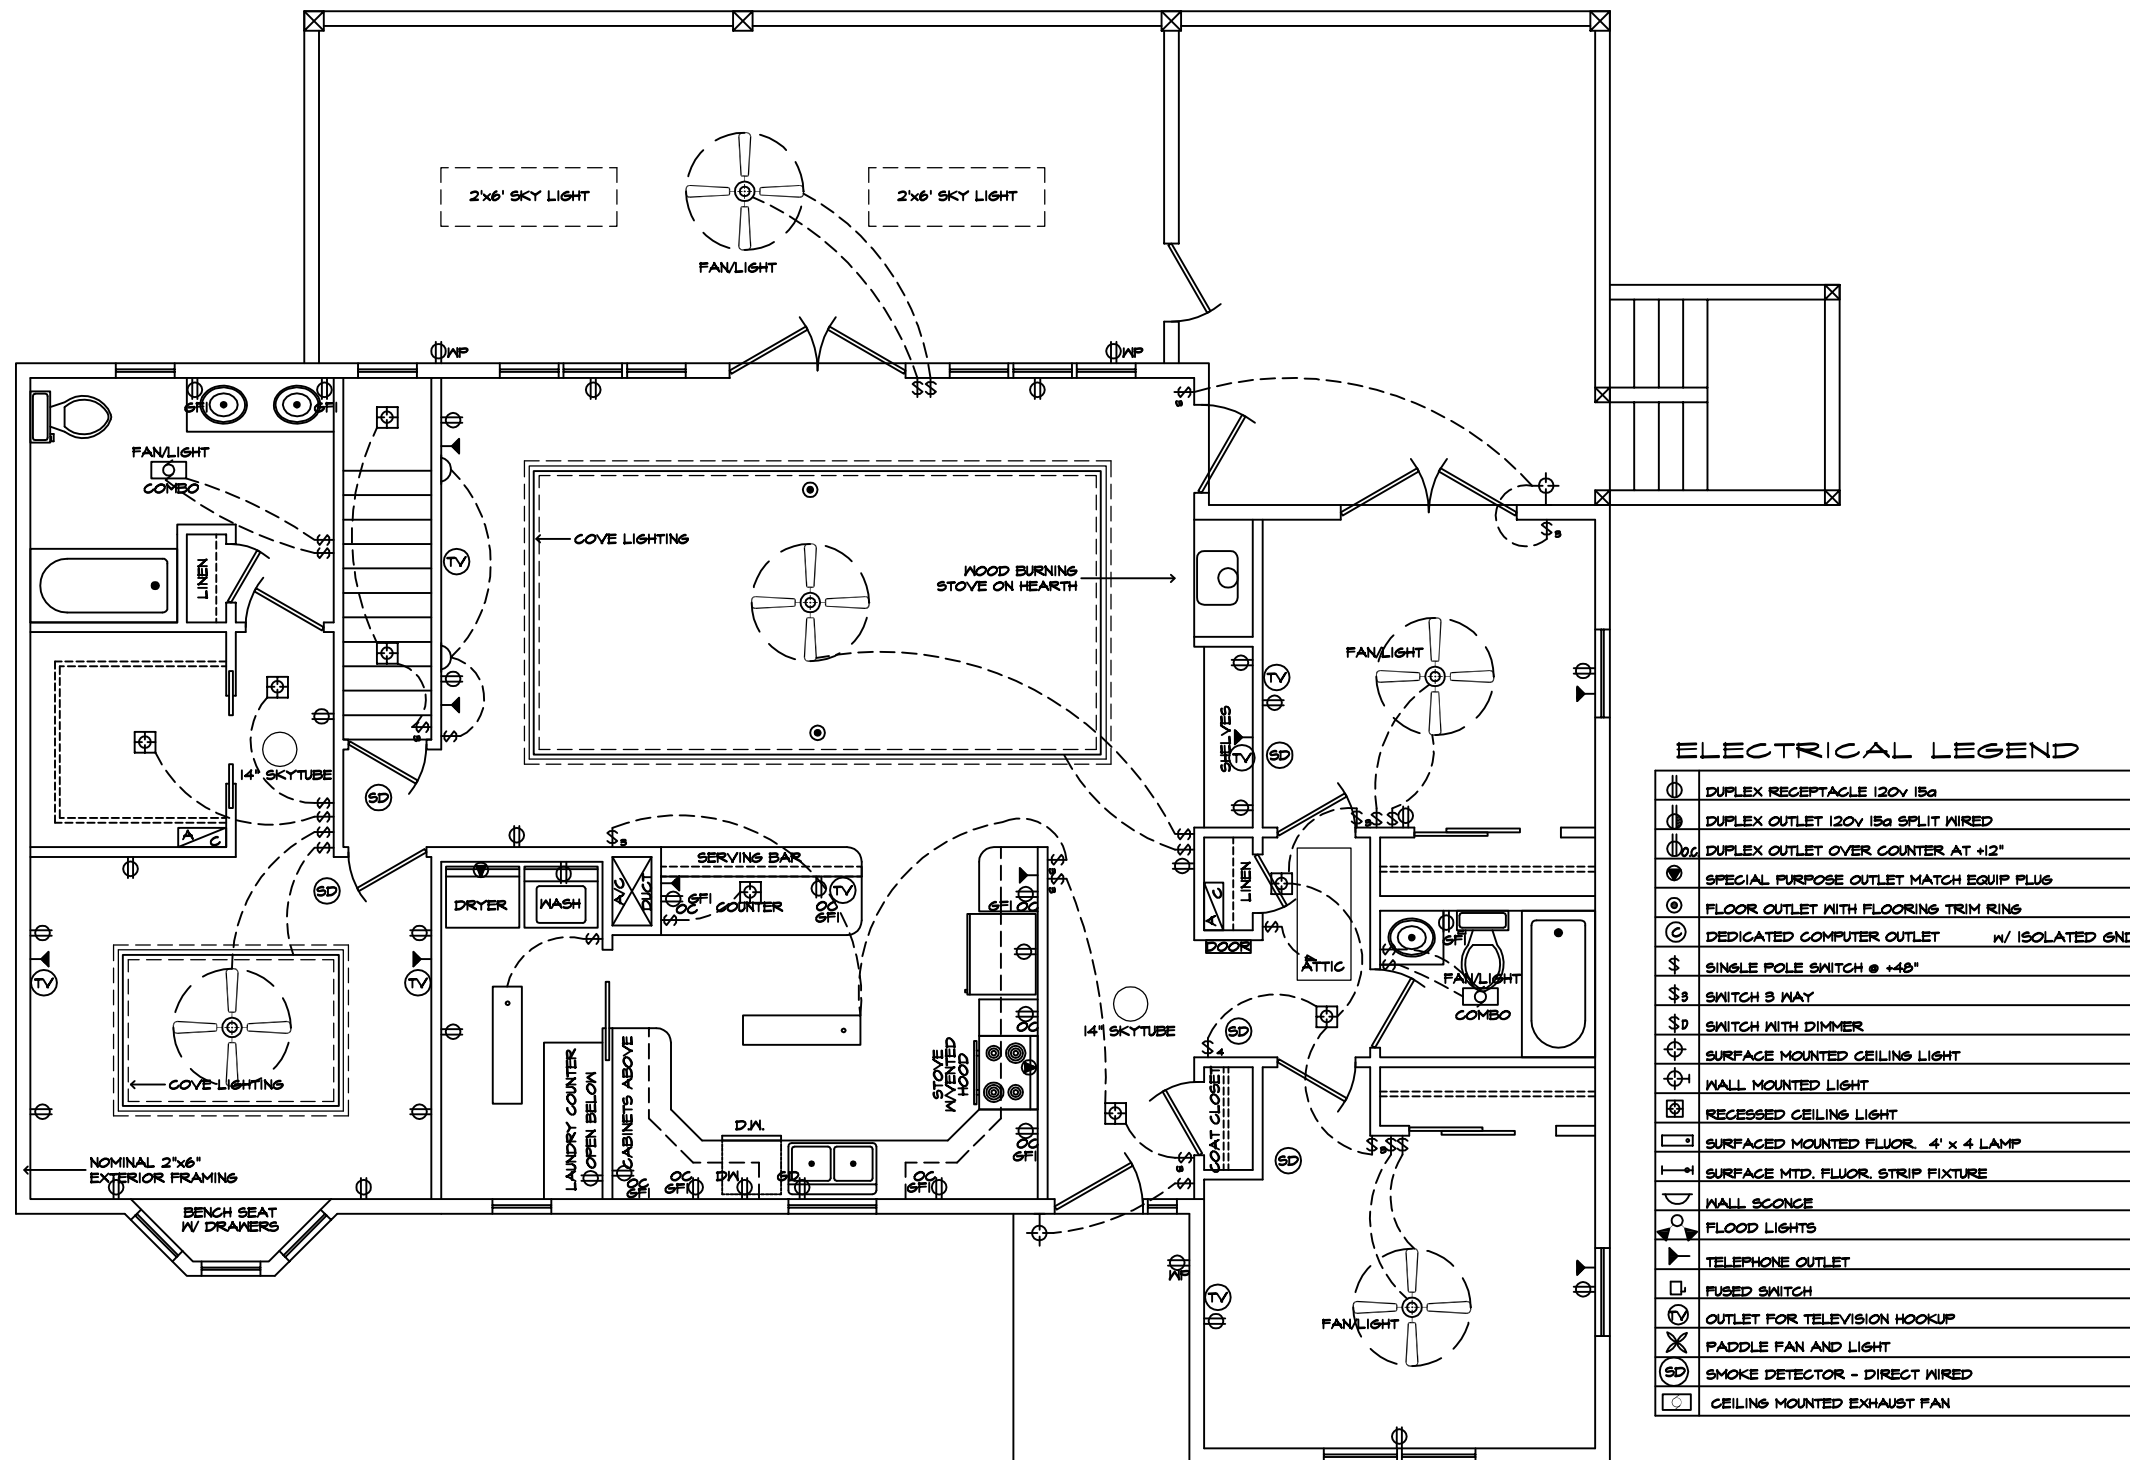

ELECTRICAL LEGEND

	DUPLEX RECEPTACLE 120v 15a
	DUPLEX OUTLET 120v 15a SPLIT WIRED
	DUPLEX OUTLET OVER COUNTER AT +2"
	SPECIAL PURPOSE OUTLET MATCH EQUIP PLUG
	FLOOR OUTLET WITH FLOORING TRIM RING
	DEDICATED COMPUTER OUTLET w/ ISOLATED GND.
	SINGLE POLE SWITCH @ +48"
	SWITCH 3 WAY
	SWITCH WITH DIMMER
	SURFACE MOUNTED CEILING LIGHT
	WALL MOUNTED LIGHT
	RECESSED CEILING LIGHT
	SURFACE MOUNTED FLOOR 4' x 4' LAMP
	SURFACE MTD. FLOOR STRIP FIXTURE
	WALL SCONCE
	FLOOD LIGHTS
	TELEPHONE OUTLET
	FUSED SWITCH
	OUTLET FOR TELEVISION HOOKUP
	PADDLE FAN AND LIGHT
	SMOKE DETECTOR - DIRECT WIRED
	CEILING MOUNTED EXHAUST FAN

FIRST FLOOR ELECTRICAL PLAN

SCALE 1/4" = 1'-0"

AUTOCAD DRAFTING PROVIDED BY:
 G. L. "CHIP" HARPER
 LOCAL: (828) 389-1547 TOLL FREE: 1-866-411-1547
 FAX: (828) 389-6372 EMAIL: CHIP@HOT4CAD.COM
 WEB: WWW.HOT4CAD.COM

PRIOR TO PERMITTING AND/OR CONSTRUCTION YOU SHOULD HAVE THESE PLANS CHECKED BY A LICENSED PROFESSIONAL FOR STRUCTURAL REQUIREMENTS, CODE AND ZONING COMPLIANCE

DATE: 04-20-2009
 SHEET: A-12